


DO NOT SCALE DRAWINGS.

CONTRACTOR MUST VERIFY ALL DRAWINGS, DIMENSIONS, DETAILS AND SPECIFICATIONS, AND REPORT ANY DISCREPANCIES TO UNION 31 INC. BEFORE PROCEEDING WITH WORK. MATERIALS MAY NOT BE SUBSTITUTED WITHOUT WRITTEN APPROVAL FROM UNION 31 INC.
ALL DRAWINGS AND SPECIFICATIONS ARE INSTRUMENTS OF SERVICE AND THE PROPERTY OF UNION 31 INC. WHICH MUST BE RETURNED AT THE COMPLETION OF THE WORK.

PRINTED: 25-F40-15

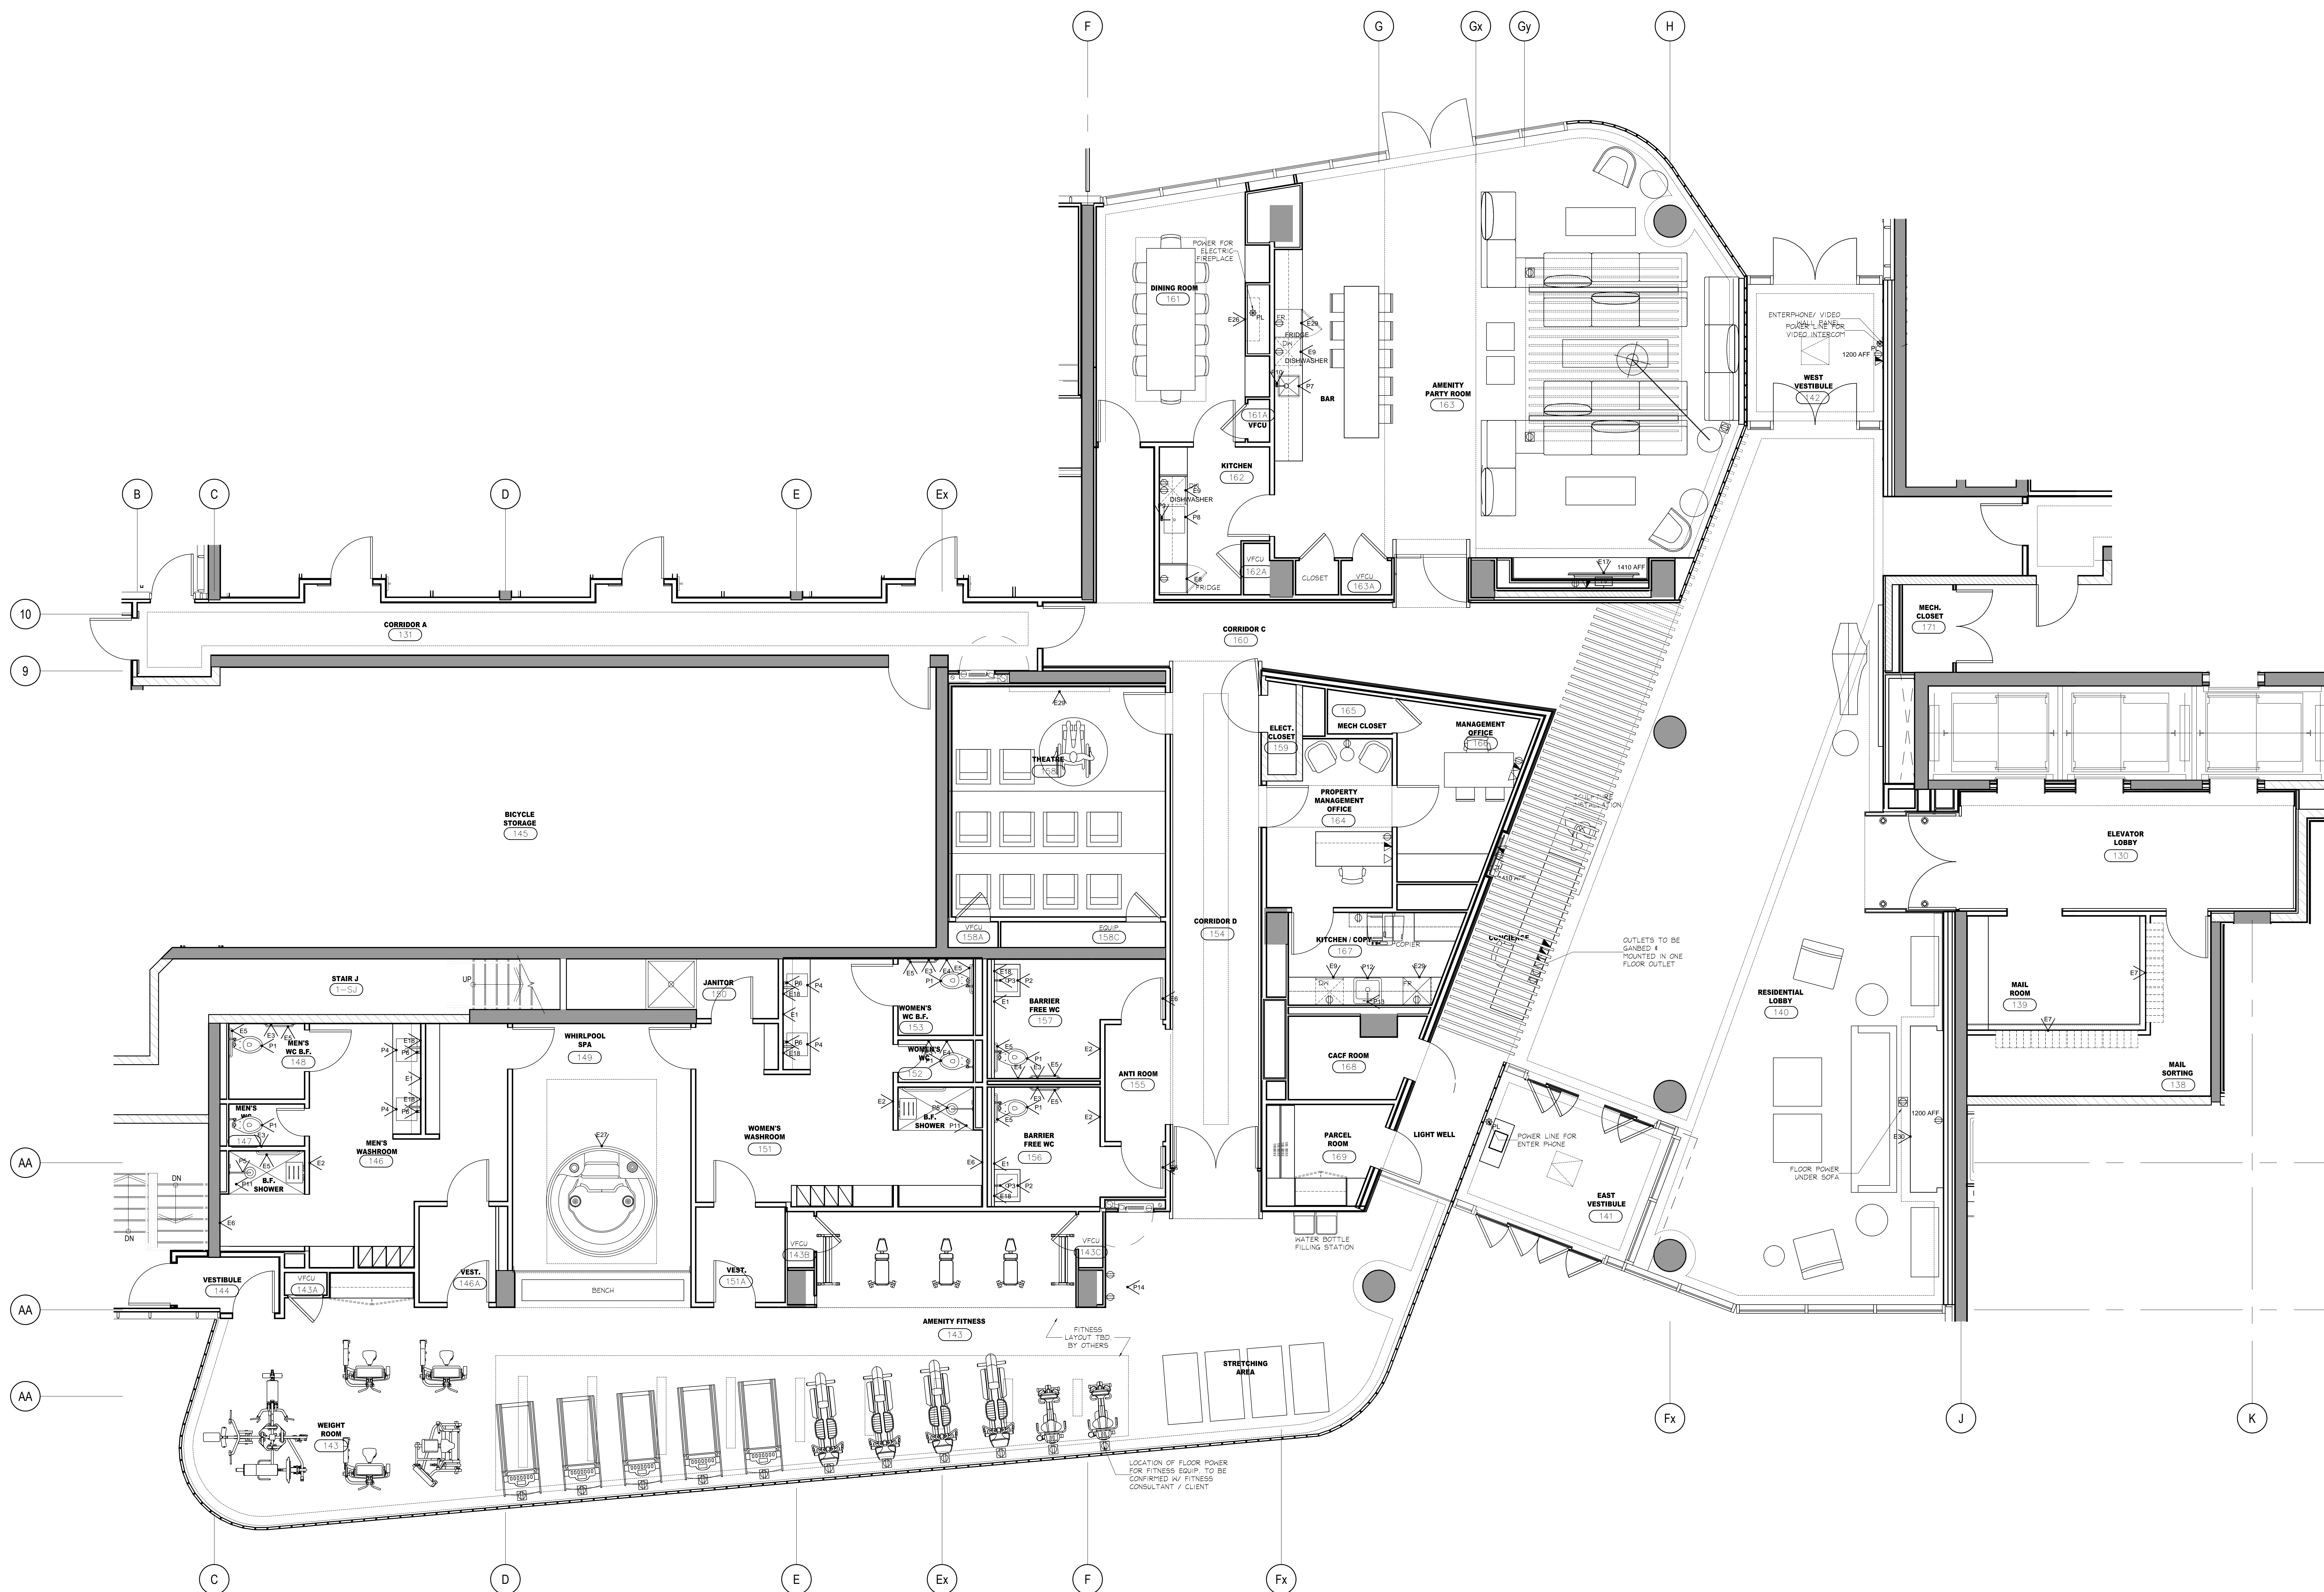

NO	DATE	COMMENTS	INI
03	26 FEB / 15	ISSUED FOR TLE TENDER	AP
02	26 JAN / 15	ISSUED FOR TENDER	AP
01	22 AUG / 14	ISSUED FOR PERMIT	AP

UNION 31
 PROJECT NAME:
**ALEXANDRA PARK
 MAIN BUILDING**
 BLOCK 11
 ON, Canada
 PROJECT NO.: 13-949
 DRAWING NO.:
**GROUND FLOOR
 FURNITURE & POWER PLAN**
 DATE STARTED: 07 AUG / 13
 SCALE: 1 : 50
 DRAWN BY: AP
 APPROVED BY: KC

1 FURNITURE & POWER PLAN
 GROUND FLOOR
 SCALE 1:50

DRAWING NO.:
**ID
 1.1.2**