



DO NOT SCALE DRAWINGS.

CONTRACTOR MUST VERIFY ALL DRAWINGS, DIMENSIONS, DETAILS AND SPECIFICATIONS, AND REPORT ANY DISCREPANCIES TO UNION 31 INC. BEFORE PROCEEDING WITH WORK. MATERIALS MAY NOT BE SUBSTITUTED WITHOUT WRITTEN APPROVAL FROM UNION 31 INC. ALL DRAWINGS AND SPECIFICATIONS ARE INSTRUMENTS OF SERVICE AND THE PROPERTY OF UNION 31 INC. WHICH MUST BE RETURNED AT THE COMPLETION OF THE WORK.


PRINTED: 25-F40-15

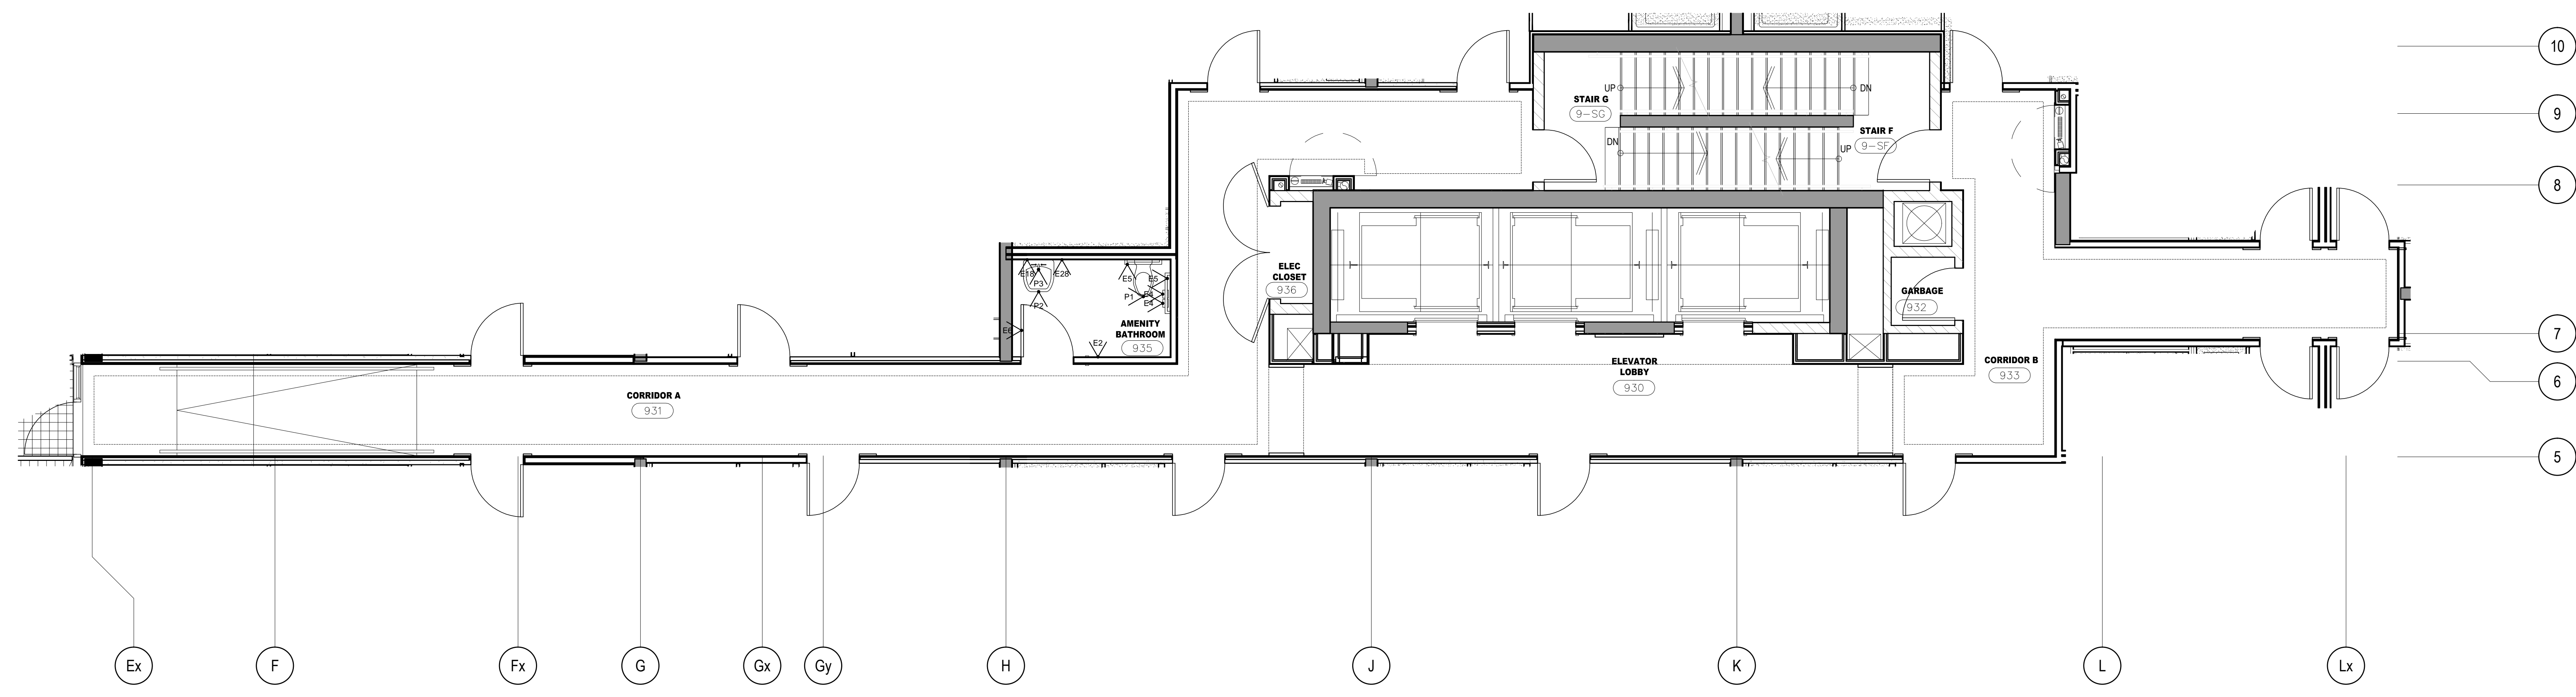

1 FURNITURE & POWER PLAN
ID1.9.1 9TH FLOOR SCALE 1:50

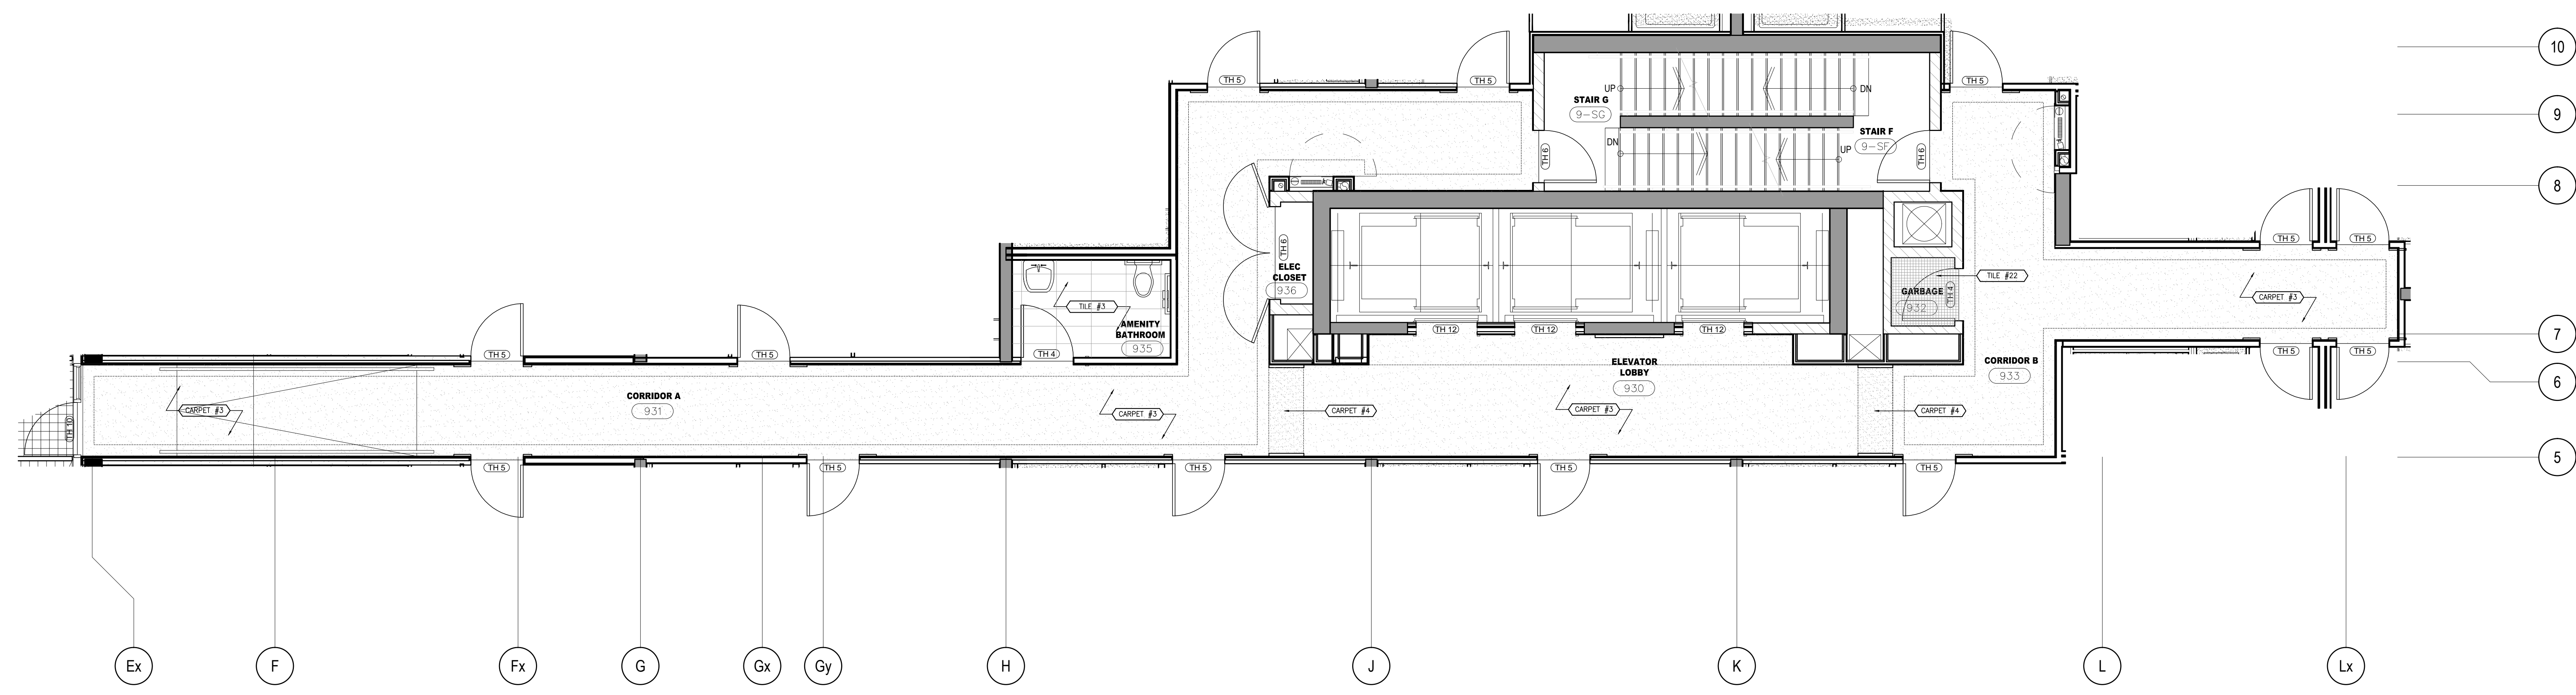

2 FLOOR FINISHES PLAN
ID1.9.1 9TH FLOOR SCALE 1:50

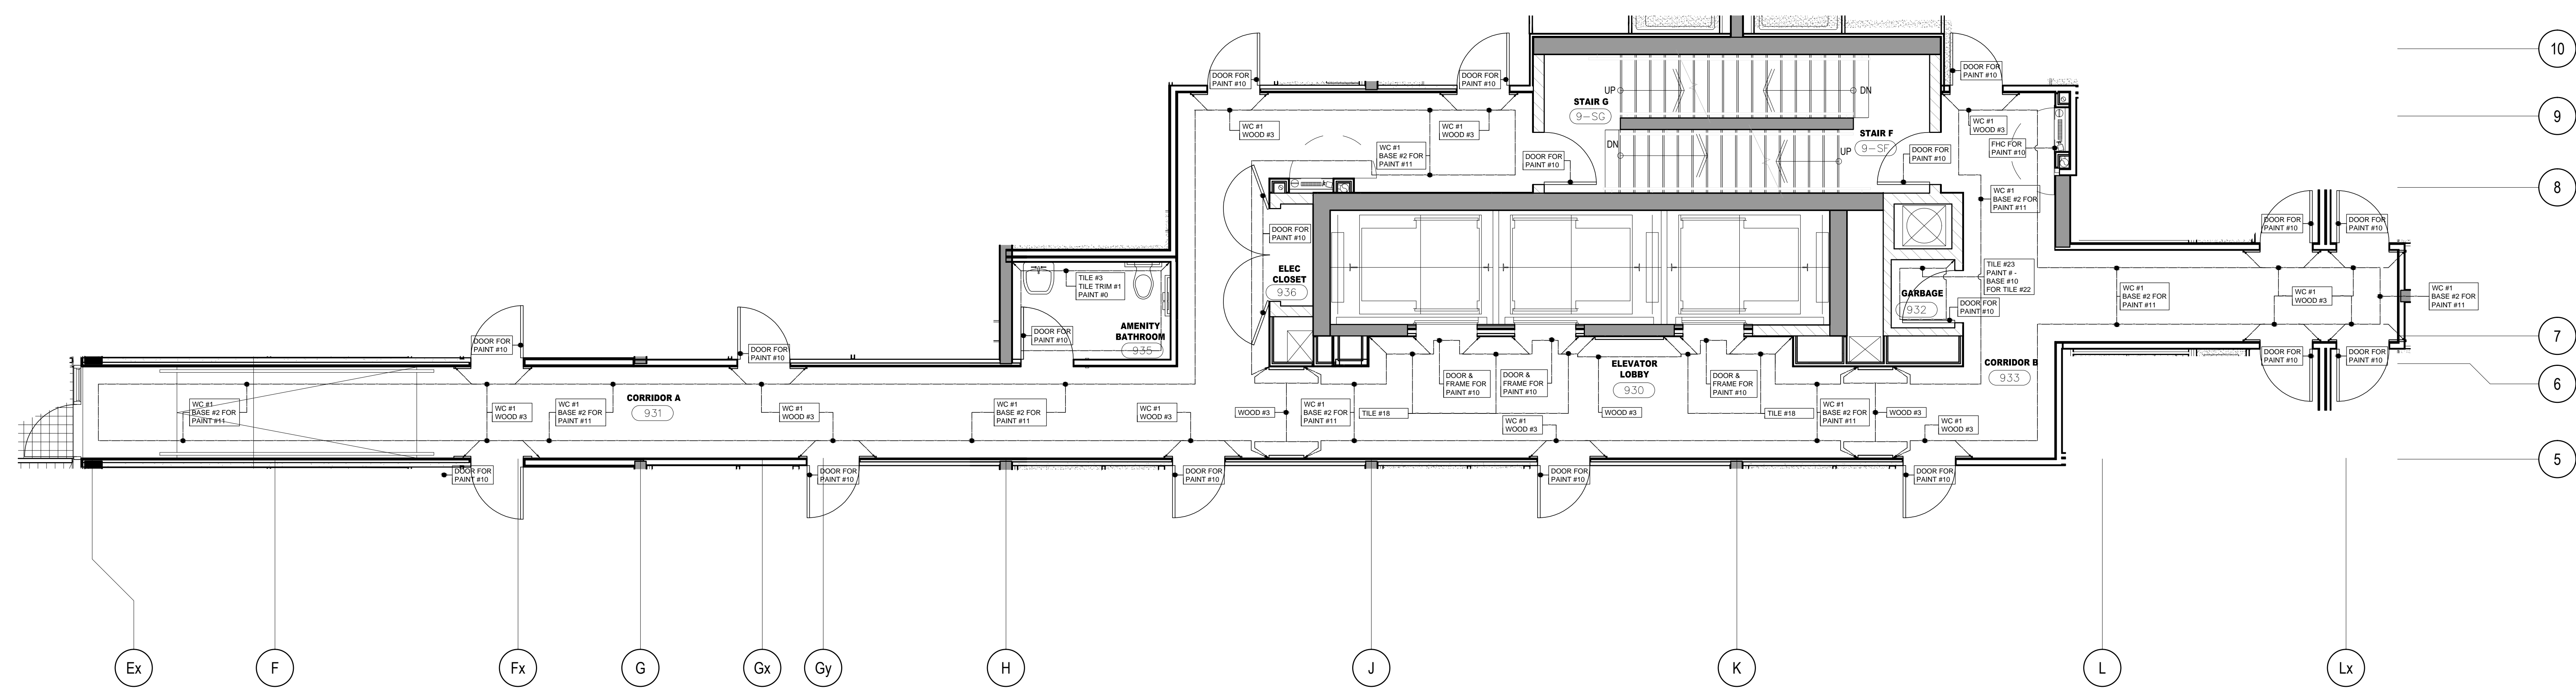

3 WALL FINISHES PLAN
ID1.9.1 9TH FLOOR SCALE 1:50

NO	DATE	COMMENTS	INI
03	26 FEB / 15	ISSUED FOR TILE TENDER	AP
02	26 JAN / 15	ISSUED FOR TENDER	AP
01	22 AUG / 14	ISSUED FOR PERMIT	AP

UNION 31

UNION 31 INC.
183 BATHURST STREET, STE. 201
TORONTO, ON, M5T 2R7, CANADA
TEL: 416-597-1576 FAX: 416-597-2139

PROJECT NAME: ALEXANDRA PARK MAIN BUILDING	
BLOCK 11 ON, Canada	
PROJECT NO.: 13-949	DRAWINGS: 9TH FLOOR FURNITURE & POWER PLAN FLOOR FINISHES PLAN & WALL FINISHES PLAN
DATE STARTED: 07 AUG / 13	DRAWING NO.: ID
SCALE: 1 : 50	APPROVED BY: KC
DRAWN BY: AP	1.9.1