

MOUNTING HEIGHT SCHEDULE
(DIMENSIONS ARE FROM FINISH FLOOR TO TOP OF WALL BOX)

| OUTLET | SUITES | PUBLIC AREA |
|-----------------------------------|--|-------------|
| RECEPTACLE | 18" FFF | 18" FFF |
| KITCHEN COUNTER SPLIT RECEPTACLE | 46" FFF | 46" FFF |
| TV/TELEPHONE (MULTI-PORT) OUTLET | 18" FFF | 18" FFF |
| LIGHT SWITCH | 38" FFF | 38" FFF |
| SECURITY PANEL | 62" FFF | 62" FFF |
| WALL THERMOSTAT | 62" FFF | 62" FFF |
| FRIDGE RECEPTACLE | TO SUIT EQUIPMENT | |
| MICROWAVE/FAN UNIT RECEPTACLE | LOCATE IN UPPER CABINET ABOVE | |
| UNDER CABINET LIGHTING RECEPTACLE | LOCATE IN UPPER CABINET ABOVE MICROWAVE / FAN UNIT | |
| INTERCOM | 41" FFF | |
| FIREFIGHTER'S HANDSET | 41" FFF | |
| PULL STATION | 41" FFF | |

GENERAL AREA CIRCUITING - TABLE #1

| LIGHTING FIXTURE LOCATION | CGT # | RECEPTACLE LOCATION | CGT # |
|---------------------------|-------|-------------------------------------|-------|
| P4 TO P1 - EXIT SIGNS | EX-XX | LOBBY (P4 TO P1) | EX-XX |
| G/F TO 10/F - EXIT SIGNS | EX-XX | STAIR "A" (5/F, 7/F, 9/F) | EX-XX |
| 11/F TO ROOF - EXIT SIGNS | EX-XX | STAIR "B" (M/F, 30/31/32/33 FLOORS) | EX-XX |
| LOBBY (P4 TO P1) | EX-XX | STAIR "B" (12/36/37 FLOORS) | EX-XX |
| STAIR "A" (P4 TO G/F) | EX-XX | STAIR "C" (M/F, 30/31/32 FLOORS) | EX-XX |
| CORRIDOR | EX-XX | STAIR "D" (18/19/20/21 FLOORS) | EX-XX |
| | EX-XX | STAIR "D" (R/F, 14 FLOORS) | EX-XX |
| | EX-XX | STAIR "E" (R/F) FLOOR | EX-XX |
| | EX-XX | CORRIDOR | EX-XX |

GENERAL NOTES - RESIDENTIAL:

- ELECTRICAL DRAWINGS SHALL BE READ IN CONJUNCTION WITH MECHANICAL, STRUCTURAL, ARCHITECTURAL AND LANDSCAPE DRAWINGS, AND COMPLY WITH ALL APPLICABLE NOTES.
- CONTRACTOR SHALL RUN CABLES WITHIN CEILING SLAB OR ENCLOSURES TO RETAIN 2 HOUR FIRE PROTECTION RATING FOR ALL LOADS THAT CONNECT TO EMERGENCY POWER.
- STAIRWAY WALL MOUNTED EMERGENCY LIGHT FIXTURES SHALL BE MOUNTED @ 1' AFF.
- EMERGENCY LIGHT FIXTURES IN LOCKERS, STORAGE, GARBAGE, UTILITY AND SERVICE ROOMS SHALL BE CONNECTED TO BOTH NORMAL AND EMERGENCY POWER AS PER DETAIL #1 OF DUG. E-35.
- FOR STORAGE ROOM VENTILATION SYSTEM, DIV. 16 TO PROVIDE CONDUIT, WIRING AND SWITCH (S) TO START/STOP FAN AND DAMPER. FAN AND 110V ACTUATOR TO BE SUPPLIED AND INSTALLED BY DIV. 15.
- FOR UTILITY ROOM VENTILATION SYSTEM, DIV. 15 WILL PROVIDE LINE VOLTAGE THERMOSTAT (T) TO DIV. 16. DIV. 16 TO PROVIDE CONDUIT AND WIRING TO START/STOP FAN AND DAMPER VIA THERMOSTAT. FAN AND 110V ACTUATOR TO BE SUPPLIED AND INSTALLED BY DIV. 15.
- REFER TO SPRINKLER DRAWINGS FOR FIRE PROTECTION DEVICE TO BE CONNECTED TO THE FIRE ALARM SYSTEM. THE DEVICE AND EQUIPMENT SHALL FORM AN INTEGRAL PART OF THE ELECTRICAL CONTRACT.
- REFER TO SUITE PANEL SCHEDULES FOR INSUITE CIRCUIT ARRANGEMENT.
- ALL DWELLING UNIT RECEPTACLES EXCEPT IN KITCHEN SHALL BE TAMPER PROOF.
- PROVIDE GROUND FAULT PROTECTION FOR SUITE KITCHEN AND WASHROOM RECEPTACLES WITHIN 1500mm OF SINK.
- PROVIDE TELECOMMUNICATION BOX C/W BUILT-IN RECEPTACLE FOR TELECOMMUNICATION. TELECOMMUNICATION BOX SHALL BE COMPLIANT WITH THE TELECOM SERVICE PROVIDER SPECIFICATION. REFER TO DETAIL #3 ON DUG. E-35 FOR TELECOM JUNCTION BOX INSTALLATION.
- DRYER SENSOR TO START DRYER VENTILATION FAN AUTOMATICALLY WHEN DRYER IS RUNNING.
- ALL SMOKE ALARMS WITHIN THE SUITE SHALL BE HARDWIRED TOGETHER AND TO A 1BA, IF CIRCUIT BREAKER AHEAD OF OTHER LOADS.
- ALL DWELLING UNIT RECEPTACLES, INCLUDING KITCHEN COUNTER RECEPTACLES OF CSA CONFIGURATION 5-15R AND 5-20R, SHALL BE TAMPER RESISTANT RECEPTACLES WITH EXCEPTION OF RECEPTACLES DEDICATED FOR STATIONARY APPLIANCES SUCH THAT THE RECEPTACLE IS RENDERED (INACCESSIBLE, OR THOSE LOCATED ABOVE 2m FROM THE FLOOR OR FINISHED GRADE. RULE 26-112(g) 26-112(h). BULLETIN 26-25-11.
- ALL BEDROOM RECEPTACLES SHALL BE CONNECTED TO ARC-FAULT CIRCUIT BREAKERS (AFGI).
- RECEPTACLES INSTALLED IN A DINING AREA FORMING PART OF A KITCHEN OF A DWELLING UNIT SHALL BE SUPPLIED BY A BRANCH CIRCUIT THAT DOES NOT SUPPLY ANY OTHER OUTLETS. RULE 26-112(e).

ELECTRICAL LEGEND

LIGHTING

- FLUORESCENT LIGHT FIXTURE TYPE AS INDICATED
- NIGHT LIGHT OR LIGHT CONNECTED TO EMERGENCY POWER
- CEILING MOUNTED WALL MOUNTED LIGHT FIXTURE
- POLE MOUNTED LIGHT FIXTURE
- CEILING TRACK LIGHT
- TRACK LIGHT
- STRIP LIGHT
- UNDER CABINET FLUORESCENT LIGHT FIXTURE
- CEILING MOUNTED EXIT SIGN
- EMERGENCY LIGHT FIXTURE
- EMERGENCY BATTERY PACK
- OCCUPANCY SENSOR POWER PACKS
- SINGLE/THREE POLE SINGLE/THREE PHASE LIGHTING
- 1/2" (12.5mm) DENOTES 3-WAY SWITCH LIGHT, OTHER SWITCHED LIGHT RESPECTIVELY
- SENSOR WALL SWITCH PULL BEEL POWERED
- OCCUPANCY SENSOR CEILING MOUNTED

POWER

- REGULAR DUPLEX RECEPTACLE
- DUPLEX RECEPTACLE GROUND FAULT INTERRUPT
- 3-20R T-LOT DUPLEX RECEPTACLE
- RECEPTACLE TYPE AND CONFIGURATION AS SPECIFIED FOR DRYER
- CONNECTION FOR OVERCLOCKTOP
- CEILING MOUNTED DEVICES
- FLOOR MOUNTED DEVICES
- DISCONNECT SWITCH NON-FUSED
- DISCONNECT SWITCH FUSED
- CORNER/STAIR RECEPTACLE
- FRACTIONAL MOTOR/FAN DIRECT CONNECTION
- DIRECT CONNECTION SINGLE PHASE
- DIRECT CONNECTION THREE PHASE
- HEAT TRACER
- DRYER SENSOR
- HEAT TRACER
- ELECTRICAL HEATER
- ELECTRICAL PANEL / SECURITY PANEL

TELECOMMUNICATION

- TV/CABLE OUTLET
- TELEPHONE OUTLET
- TELEPHONE CABLE (MULTI-PORT OUTLET)
- DATA OUTLET
- DATA/TELEPHONE OUTLET
- IN SUITE TELECOM BOX C/W RECEPTACLE
- LIFT LOCATION
- MUSIC SPEAKER / VOLUME CONTROL
- RADIO RECEIVER

SECURITY

- INTERCOM / INTERPHONE
- INTERCOM WITH CAMERA
- PANIC BUTTON / PANIC INTERCOM STATION
- CARD READER
- AUTOMATIC RELEASE CARD ACCESS/RADIO RECEIVER
- ELECTRIC STRIKE
- MAGLOCK
- DOOR CONTACT / WINDOW CONTACT
- AUTOMATIC DOOR OPERATOR
- VISION DETECTOR
- PUSH BUTTON
- SECURITY CAMERA

LIFE SAFETY

- FIRE ALARM SPOKE DETECTOR
- SPOKE ALARM
- FIRE ALARM DUCT TYPE SPOKE DETECTOR
- FIRE ALARM HEAT DETECTOR
- FIXED TEMP. 57° C SMOKE HEAT DETECTOR
- MOISTURE PROOF HEAT DETECTOR
- CO ALARM
- COMBINATION SPOKE & CO ALARM
- CO SENSOR / NO SENSOR
- FIRE ALARM MANUAL PULL STATION
- REFRESHERS HANDSET
- FIRE ALARM STROBEOHORN WALL MTD.
- FIRE ALARM HORN WALL MTD.
- FIRE ALARM HORN CEILING MTD.
- FIRE ALARM SPEAKER CEILING MTD.
- FIRE ALARM ANNUNCIATOR PANEL
- FIRE ALARM CONTROL PANEL

KEY NOTES - RESIDENTIAL:

- FOR CIRCUITING, REFER TO TABLE #1.
- PROVIDE ALARM SPEAKER SMOKE DETECTOR AND RECEPTACLE AT EVERY THIRD FLOOR STAIR WELL STARTING FROM TOP FLOOR, AS PER TO DUG. E-32 FOR FIRE ALARM RISER DIAGRAM.
- REFER TO SUPERVISED VALVE AND FLOW SWITCH SCHEDULE ON DUG. E-XX FOR DETAILS ON TYPICAL FLOORS.
- PROVIDE TELECOMMUNICATION BACKBOARD C/W 15A, 1A 15A RECEPTACLE AS PER COMMUNICATION RISER DIAGRAM ON DUG. E-31.
- CONTRACTOR SHALL REFER TO ELECTRICAL SINGLE LINE DIAGRAM ON DUG. E-30 AND SDP RISER ON DUG. E-31 FOR SDP LOCATIONS AND DISTRIBUTION.
- PROVIDE CONDUIT AS PER RISER DETAIL #8 ON DUG. E-35 FOR E/BORTER/TRIBORTER CONTROL SYSTEM.
- ALL SUITE DOOR CONTACTS WILL COMPLETE WITH INTRUSION ALARM SYSTEM THAT CONTACT TO THE CONCIERGE STATION.
- DESIGNATED "LAUNDRY RECEPTACLE" AS DEFINED BY ESA CODE 26-112(e)(1), 26-112(b) AND ESA BULLETIN 26-26-2 (WITHIN 3m RADIUS OF LAUNDRY CLOSET). RECEPTACLE SHALL BE CONNECTED TO A DEDICATED CIRCUIT. SEE DETAIL #4 ON DUG. E-35.
- SWITCHES, RECEPTACLES, ETC. TO BE INSTALLED AS TO NOT INTERFERE WITH THE OPENING AND OPERATION OF SLIDING DOOR.
- FOR FAN COIL UNITS (FCU-X), ELECTRICAL CONTRACTOR TO SUPPLY AND INSTALL CONDUIT, AND JUNCTION BOX FOR REMOTE THERMOSTAT. MECHANICAL CONTRACTOR SUPPLY AND WIRE THERMOSTATS, MOUNT THERMOSTAT AND TERMINATE WIRING.

REVISIONS


| NO. | DATE | DESCRIPTION |
|-----|------|-------------|
| | | |
| | | |

CONTRACTOR MUST CHECK AND VERIFY ALL DIMENSIONS AND CONDITIONS ON THE JOB AND REPORT CORRECTIONS TO THE ENGINEERS BEFORE PROCEEDING WITH THE WORK. THIS DRAWING IS THE PROPERTY OF THE ENGINEERS AND ARCHITECTS. IT IS TO BE KEPT AT ALL TIMES. DRAWINGS ARE NOT TO BE SCALED.

NOVA TREND

1715 West Beaver Creek Road, Unit 31
Richmond Hill, Ontario L4B 3M1
Tel: 905-882-5445
Fax: 905-882-5441
Email: sales@novatrendeng.com

DATE: FEB 13 1313
PROJECT NUMBER: 1313
DRAWING NUMBER: E-11

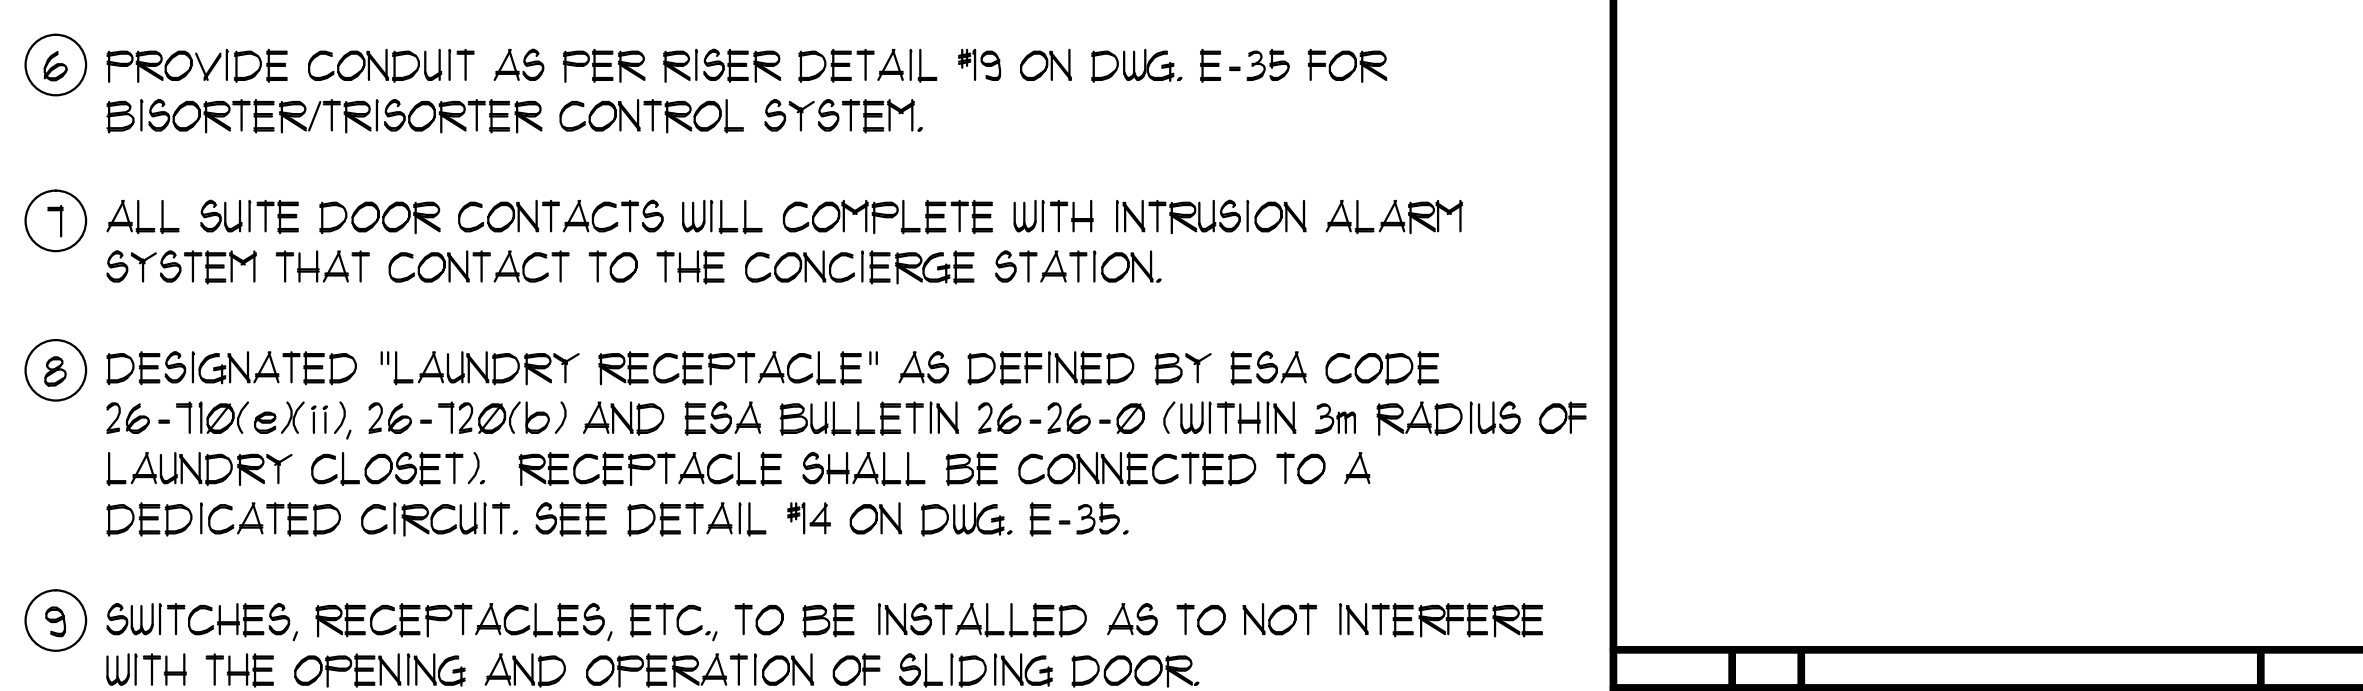

Drawing Name: V:\020000\Current\DWG\31313 - Alexandra Park\031313 - 10.11.dwg (ELED.dwg) Printed: Jan 10, 2014 - 11:30am