


- POOL KEY NOTES:**
- PROVIDE TELEPHONE AS PER OBC 3.11.01 (8) AND SHALL BE INSTALLED WITHIN 30m OF THE POOL.
 - ALL RECIRCULATING PUMPS SHALL BE CAPABLE OF BEING DEACTIVATED BY AN EMERGENCY STOP BUTTON. CLEARLY LABELED AND LOCATED ON THE DECK AREA.
 - AN EMERGENCY SIGN CONTAINING THE WORDS "IN THE EVENT OF AN EMERGENCY, PUSH EMERGENCY STOP BUTTON AND USE EMERGENCY PHONE, AUDIBLE AND VISUAL SIGNAL WILL ACTIVATE" SHALL BE IN LETTERS AT LEAST 25mm HIGH WITH A 5mm STROBE. POST THE SIGN ABOVE THE EMERGENCY STOP BUTTON.
 - DIV. 16 TO PROVIDE 100A, 3P DISCONNECT IN POOL MECHANICAL ROOM FOR TURN-KEY POOL CONTRACTOR'S USE.
 - EXACT LOCATIONS OF OUTLETS TO BE DETERMINED ON SITE.
 - THIS LAYOUT AND CIRCUITING ARE FOR INFORMATION ONLY. CONTRACTOR SHALL CONFIRM WITH SHOP DRAWINGS FOR FINAL EQUIPMENT LAYOUT AND QUANTITY.
 - EMERGENCY LIGHT FIXTURES IN LOCKERS, STORAGE, GARBAGE, UTILITY AND SERVICE ROOMS SHALL BE CONNECTED TO BOTH NORMAL AND EMERGENCY POWER AS PER DETAIL #21 OF DWG. E-35.

- POOL EQUIPMENTS:**
- SFA JET PUMP
575V, 3φ, 5HP
CCT. FROM (FP-F)
 - SFA FILTER PUMP
575V, 3φ, 3/4HP
CCT. FROM (FP-F)
 - TUB JET PUMP
575V, 3φ, 3/4HP
CCT. FROM (FP-F)
 - TUB FILTER PUMP
575V, 3φ, 3/4HP
CCT. FROM (FP-F)
 - CHEMICAL CONTROLLER
120V, 1φ, 15A
CCT. (P-2)
 - WATER LEVEL CONTROL SYSTEM
120V, 1φ, 15A
CCT. (P-6)
 - WATER FEATURE UV SYSTEM
120V, 1φ, 15A
CCT. (P-6)
 - TWO (2) DECK BOXES FOR POOL LIGHTING. LOCATION TO BE DETERMINED BY POOL CONTRACTOR. LIGHTING WITHIN SWIMMING POOL TO BE PROVIDED BY POOL CONSULTANT. POOL CONTRACTOR IS RESPONSIBLE FOR WIRING FROM DECK BOX TO WATER FEATURE. SHALL BE DONE BY POOL CONTRACTOR. ELECTRICAL CONTRACTOR IS RESPONSIBLE FOR WIRING FROM 6" MECHANICAL ROOM TO DECK BOX (DECK BOX TO BE PROVIDED BY POOL CONSULTANT).
 - RUN 2-3/4" CONDUIT TO DECK BOXES
 - STEAM GENERATOR
575V, 3φ, 36KW
CONN. TO FP-F
 - SAUNA HEATER
575V, 3φ, 2KW
CONN. TO FP-F
 - HYDROTHERAPY BOOSTER PUMP
575V, 3φ, 3HP
CONN. TO FP-F
 - TUB ACID FEED PUMP
120V, 1φ
CONN. TO P-3

GENERAL AREA CIRCUITING - TABLE #1

LIGHTING FIXTURE LOCATION	CCT. #
P2 TO P1 - EXIT SIGNS	E-1
G/F TO MPH - EXIT SIGNS	E-3
MPH - EXIT SIGNS	E-1
STAIR 'A' (P2 TO G/F)	E-5
STAIR 'B' (P2 TO G/F)	E-5
STAIR 'U' (G/F TO 4/F)	E-9
STAIR 'U' (5/F TO 9/F)	E-11
STAIR 'G' (G/F TO 14/F)	E-13
STAIR 'F' (G/F TO 14/F)	E-5
STAIR 'K' (4/F TO MPH) & MPH (G/F)	ER-3ER-5R-1R-1R
(G/F)	E-2E-4E-6E-10E-8E-10E-12E-14E-
(G/F)	B1-2B1-4B1-6B1-8B1-10B1-12B1-14B1-16B1-18B1-20B1-22B1-24B1-26B1-28B1
CORRIDOR (2/F & 3/F)	E-24
CORRIDOR (4/F & 5/F)	E-26
CORRIDOR (6/F & 7/F)	E-28
CORRIDOR (8/F TO 11/F)	E-30
CORRIDOR (12/F TO 14/F)	E-32
CORRIDOR 4 LOCKER (2/F)	B-46
CORRIDOR (3/F)	B-48
CORRIDOR (4/F)	B-50
CORRIDOR (5/F & 6/F)	B-52
CORRIDOR (7/F & 8/F)	B-54
CORRIDOR (9/F TO 11/F)	B-56
CORRIDOR (12/F TO 14/F)	B-58
ELEVATOR CAB	ER-6 ER-8ER-10
EXTERIOR SITE	E1-E1-3E1-5E1-7E1-9E1-11E1-13
RECEPTACLE LOCATION	CCT. #
ELEC. S. CLOSET (G/F TO 3/F)	B-2
ELEC. N. CLOSET (2/F TO 3/F)	B-4
ELEC. N. CLOSET (10/F TO 14/F)	B-6
ELEC. N. CLOSET (22/F TO 32/F)	B-8
ELEV. LOBBY (P2 TO 8/F)	B-10
CORRIDOR (2/F TO 8/F)	B-12B-14B-16B-18B-20B-22B-24
CORRIDOR (2/F TO 5/F)	B-26B-28
ELEV. LOBBY (9 TO 14/F)	B-30
CORRIDOR (9/F TO 14/F)	B-32B-34B-36B-38
STAIR A (G/F & 1/3/F/6/F/3/F)	B-40
STAIR F (14/F)/F/B/F/2/F	B-42
STAIR H (14/F)/F/B/F/2/F	B-44
STAIR 'K' 4 MPH	R-2

- KEY NOTES - INSUITE:**
- DESIGNATED "LAUNDRY RECEPTACLE" AS DEFINED BY ESA CODE 26-110(e)(1), 26-120(e) AND ESA BULLETIN 26-26-0 (WITHIN 3m RADIUS OF LAUNDRY CLOSET). RECEPTACLE SHALL BE CONNECTED TO A DEDICATED CIRCUIT. SEE DETAIL #4 ON DWG. E-35.
 - SUITE DOOR CONTACTS AND GLASS BREAK DETECTOR WILL COMPLETE WITH INTRUSION ALARM SYSTEM THAT CONTACT TO THE CONCIERGE STATION. (TYPICAL)
 - FOR FAN COIL UNITS (FCU) ELECTRICAL CONTRACTOR TO SUPPLY AND INSTALL CONDUIT AND JUNCTION BOX FOR REMOTE THERMOSTAT. MECHANICAL CONTRACTOR SHALL SUPPLY WIRE, TERMINATE WIRING AND MOUNT THERMOSTAT.
 - INSTALL SIDE-MOUNTED RECEPTACLE ON KITCHEN ISLAND CABINET.
 - SWITCHES, RECEPTACLES, ETC. TO BE INSTALLED AS TO NOT INTERFERE WITH THE OPENING AND OPERATION OF SLIDING DOOR.

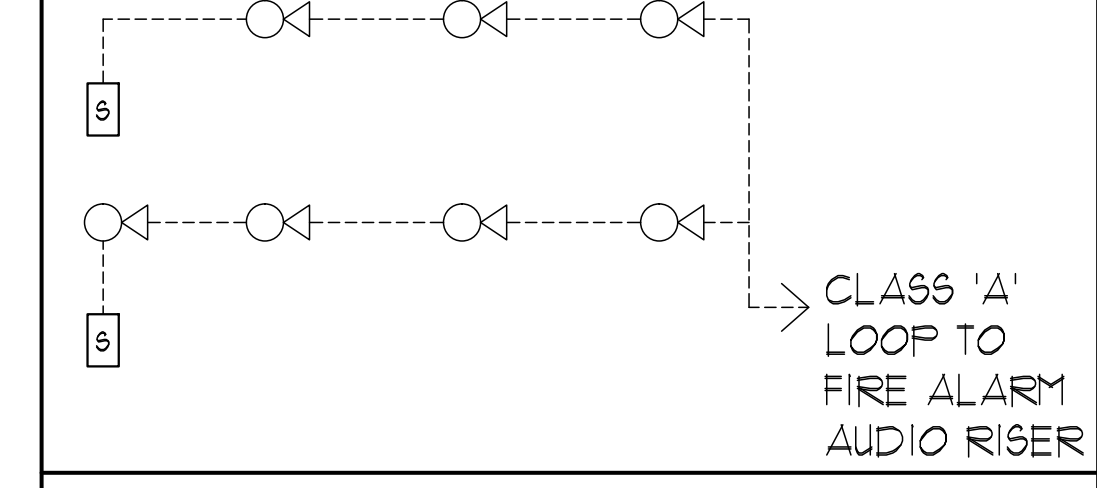

SUITE FIRE ALARM SYSTEM CONNECTION DIAGRAM

MOUNTING HEIGHT SCHEDULE (TO TOP OF BOX)

OUTLET	SUITES	PUBLIC AREA
RECEPTACLE	400 MM AFF.	400 MM AFF.
TV OUTLET	400 MM AFF.	400 MM AFF.
TELEPHONE OUTLET	400 MM AFF.	400 MM AFF.
MULTI-PORT OUTLET	400 MM AFF.	400 MM AFF.
SWITCH	1200 MM AFF.	1200 MM AFF.
SECURITY PANEL	1200 MM AFF.	
SILENCE SWITCHES	1200 MM AFF.	
THERMOSTAT	1200 MM AFF.	1200 MM AFF.
INTERCOM		1200 MM AFF.
Y.C. HANDSET		1200 MM AFF.
FULL STATION		1200 MM AFF.

- GENERAL NOTES - RESIDENTIAL:**
- ELECTRICAL DRAWINGS SHALL BE READ IN CONJUNCTION WITH MECHANICAL, STRUCTURAL, ARCHITECTURAL AND LANDSCAPE DRAWINGS.
 - CONTRACTOR SHALL RUN CABLES WITHIN CEILING SLAB OR ENCLOSURES TO RETAIN 2 HOUR FIRE PROTECTION RATING FOR ALL LOADS THAT CONNECT TO EMERGENCY POWER.
 - FIRE ALARM RISERS SHALL BE RUN IN 2 HOUR FIRE RATED ELECTRICAL CLOSET. REFER TO DWG. E-37 FOR RISER DIAGRAM AND DETAILS.
 - STAIRWAY WALL MOUNTED EMERGENCY LIGHT FIXTURES SHALL BE MOUNTED @ 1' AFF. MIN.
 - FOR STORAGE ROOM VENTILATION SYSTEM, DIV. 16 TO PROVIDE CONDUIT, WIRING AND SWITCH (S) TO START/STOP FAN AND DAMPER. FAN AND 110V ACTUATOR TO BE SUPPLIED AND INSTALLED BY DIV. 15.
 - FOR UTILITY ROOM VENTILATION SYSTEM, DIV. 15 WILL PROVIDE LINE VOLTAGE THERMOSTAT (T) TO DIV. 16. DIV. 16 TO PROVIDE CONDUIT AND WIRING TO START/STOP FAN AND DAMPER VIA THERMOSTAT. FAN AND 110V ACTUATOR TO BE SUPPLIED AND INSTALLED BY DIV. 15.
 - FOR UNIT HEATER, DIV. 15 TO PROVIDE LINE VOLTAGE THERMOSTAT (T), DIV. 16 TO PROVIDE CONDUIT AND WIRING TO START/STOP UNIT HEATER.
 - REFER TO SPRINKLER DRAWINGS FOR FIRE PROTECTION DEVICE TO BE CONNECTED TO THE FIRE ALARM SYSTEM. THE DEVICE AND EQUIPMENT SHALL FORM AN INTEGRAL PART OF THE ELECTRICAL CONTRACT.
 - DIV. 16 SHALL SUPPLY AND INSTALL CONDUITS, WIRES AND INTERLOCK FANS TO MOTORIZED DAMPERS AND TO THE THERMOSTAT.
 - DIV. 16 SHALL SUPPLY AND INSTALL CONDUITS, WIRES AND INTERLOCK FANS TO MOTORIZED DAMPERS AND TO THE THERMOSTAT.
 - REFER TO SUITE PANEL SCHEDULES FOR INSUITE CIRCUIT ARRANGEMENT.
 - ALL DUELLING UNIT RECEPTACLES EXCEPT IN KITCHEN SHALL BE TAMPER PROOF.
 - PROVIDE GROUND FAULT PROTECTION FOR SUITE KITCHEN AND WASHROOM RECEPTACLES WITHIN 1500mm OF SINK.
 - PROVIDE TELECOMMUNICATION BOX C/W BUILT-IN RECEPTACLE FOR TELECOMMUNICATION. TELECOMMUNICATION BOX SHALL BE COMPLIANT WITH THE TELECOM SERVICE PROVIDER SPECIFICATION. REFER TO DETAIL #3 ON DWG. E-35 FOR TELECOM JUNCTION BOX INSTALLATION.
 - DRYER SENSOR TO START DRYER VENTILATION FAN AUTOMATICALLY WHEN DRYER IS RUNNING.
 - ALL SMOKE ALARMS WITHIN THE SUITE SHALL BE HARDWIRED TOGETHER AND TO A 15A, 1P CIRCUIT BREAKER AHEAD OF OTHER LOADS.

- KEY NOTES - RESIDENTIAL - COMMON AREA:**
- FOR CIRCUITING, REFER TO TABLE #1.
 - PROVIDE ALARM SPEAKER, SMOKE DETECTOR AND RECEPTACLE AT EVERY THIRD FLOOR STAIR WELL STARTING FROM TOP FLOOR, AS PER TO DWG. E-32 FOR FIRE ALARM RISER DIAGRAM.
 - INSTALL SIDE-MOUNTED RECEPTACLE ON KITCHEN ISLAND CABINET.
 - PROVIDE TELECOMMUNICATION BACKBOARD C/W 15A, 1P 15A RECEPTACLE AS PER COMMUNICATION RISER DIAGRAM ON DWG. E-31.
 - CONTRACTOR SHALL REFER TO ELECTRICAL SINGLE LINE DIAGRAM ON DWG. E-30 AND SDP RISER ON DWG. E-31 FOR SDP LOCATIONS AND DISTRIBUTION.
 - PROVIDE CONDUIT AS PER RISER DETAIL #9 ON DWG. E-35 FOR BISORTER/TRISORTER CONTROL SYSTEM.
 - REFER TO SUPERVISED VALVE AND FLOW SWITCH SCHEDULE ON DWG. E-33 FOR DETAILS ON TYPICAL FLOORS.
 - EMERGENCY LIGHT FIXTURES IN LOCKERS, STORAGE, GARBAGE, UTILITY AND SERVICE ROOMS SHALL BE CONNECTED TO BOTH NORMAL AND EMERGENCY POWER AS PER DETAIL #21 OF DWG. E-35.
 - ALLOCATE 2, 120V, 15A, CIRCUITS FROM PANEL LP-F FOR MECHANICAL CONTROL, CONTRACTOR COORDINATE WITH DIV. 15 FOR EXACT LOCATION.
 - SWING STAGE WINDOW WASHING TWIST LOCK WITH LOCKOUTS RECEPTACLE 30A, 3φ, 208V, 5WIRE (1B-30R).

HEAT LOSS REPLACEMENT

PYROTEXAX	CAT #	DESCRIPTION	QUANTITY
PYROTEXAX	SUBS	HOPE JACKETED COPPER SHEATHED MI HEATING CABLE (P)	1 EACH
PYROTEXAX	DIGITRACE	JUNCTION BOX (3 ENTRY)	1 EACH
ET1	GIT-1	AUTOMATIC SNOW MELTING CONTROLLER 208/240V	1 EACH
ET1	SIT-8E	OVERHEAD SNOW SENSOR	1 EACH
ET1	SIT-8E	RAVENEHANT MOUNTED SENSOR - OPTIONAL REPLACEMENT FOR OVERHEAD SENSOR FOR BETTER SENSING	0 EACH
ET1	SIT-8E	SNOW MELT CAUTION SIGN	2 EACH

- NOTES:**
- THE SYSTEM WILL BE PENTAIR 208V, 3φ, 9kW.
 - CONTRACTOR TO VERIFY MATERIAL LIST IS SUITABLE FOR THE ACTUAL SITE MEASUREMENTS AND CONDITIONS.
 - ELECTRICAL DIVISION TO COORDINATE WITH LANDSCAPE AND STRUCTURAL DISCIPLINES FOR CONSTRUCTION DETAILS OF POLE BASES.

ELECTRICAL LEGEND

LIGHTING

- FLUORESCENT LIGHT FIXTURE TYPE AS INDICATED
- NIGHT LIGHT OR LIGHT CONNECTED TO EMERGENCY POWER
- CEILING MOUNTED WALL MOUNTED LIGHT FIXTURE
- POLE MOUNTED LIGHT FIXTURE
- INScribed LETTER DENOTES TYPE
- CAPPED CEILING LIGHT OUTLET
- TRACK LIGHT
- STREP LIGHT
- UNDER CABINET FLUORESCENT LIGHT FIXTURE
- CEILING MOUNTED WALL MOUNTED EXIT SIGN
- SINGLE/DOUBLE EMERGENCY LAMP REPEATE HEAD
- EMERGENCY BATTERY PACK
- OCCUPANCY SENSOR POWER RACKS
- SINGLE/DOUBLE POLE SINGLE/DOUBLE THROUGH TUGGLE SWITCH RESPECTIVELY
- 13" X 19" 12" DIAMETER 3-WAY-4-WAY PULL LIGHT, OTHER SWITCHED LIGHT RESPECTIVELY
- MASTER LIGHTING SHUT-OFF SWITCH
- SENSOR WALL SWITCH FIRE SELF POWERED
- OCCUPANCY SENSOR CEILING MOUNTED

POWER

- REGULAR DUPLEX RECEPTACLE
- DUPLEX RECEPTACLE GROUND FAULT INTERRUPT
- 3-POLE 4-WIRE DUPLEX RECEPTACLE
- SINGLE RECEPTACLE TYPE AND CONFIGURATION AS SPECIFIED FOR ORDER
- CONNECTION FOR OVERHEAD/COOP
- ABOVE COUNTER DEVICE
- CEILING MOUNTED DEVICES
- FLOOR MOUNTED DEVICES
- DISCONNECT SWITCH NON-FUSED
- DISCONNECT SWITCH FUSED
- COBINATION STARTER
- FRACTIONAL MOTOR/ANALOG DIRECT CONNECTION
- DIRECT CONNECTION SINGLE PHASE
- DIRECT CONNECTION THREE PHASE
- THERMOSTAT
- DRYER SENSOR
- HEAT TRIGGE
- ELECTRICAL HEATER
- ELECTRICAL PANEL / SECURITY PANEL

TELECOMMUNICATION

- TV/CABLE OUTLET
- TELEPHONE CABLE (MULTI-PORT OUTLET)
- DATA/TELEPHONE OUTLET
- N IN SUITE TELECOM BOX C/W RECEPTACLE
- WIRE LOCATION
- WIRE LOCATION - VOLUME CONTROL
- RADIO RECEIVER

SECURITY

- INTERCOM / EXTERIORPHONE
- INTERCOM WITH CAMERA
- PANIC BUTTON / PANIC INTERCOM STATION
- CAAO READER
- AUTOMATIC RELEASE CARD ACCESS-RADIO RECEIVER
- ELECTRIC STRIKE
- MAGLOCK
- DOOR CONTACT / WINDOW CONTACT
- GLASS BREAK DETECTOR
- AUTOMATIC DOOR OPERATOR
- MOTION DETECTOR
- PUSH BUTTON
- SECURITY CAMERA

LIFE SAFETY

- FIRE ALARM SMOKE DETECTOR
- SMOKE ALARM
- FIRE ALARM DUCT TIE SMOKE DETECTOR
- FIRE ALARM HEAT DETECTOR
- FIXED TEMP. 68° DISERGE-HEAT DETECTOR
- POSSIBLE PROOF HEAT DETECTOR
- CO ALARM
- COBINATION SMOKE & CO ALARM
- CO SENSOR / NO SENSOR
- FIRE ALARM MANUAL PULL STATION
- FIREFIGHTER'S HANDSET
- FIRE ALARM SMOKE/HEAT WALL MTD.
- FIRE ALARM INTRUSION WALL MTD.
- FIRE ALARM SPEAKER/STROBE CEILING MTD.
- FIRE ALARM SPEAKER CEILING MTD.
- FIRE ALARM ANNUNCIATOR PANEL
- FIRE ALARM CONTROL PANEL

REVISIONS

NO.	DATE	DESCRIPTION
1	02/13/14	ISSUED FOR TENDER
2	02/13/14	REVISED FOR PERMIT
3	02/13/14	ISSUED FOR PERMIT
4	02/13/14	REVISED FOR PERMIT
5	02/13/14	ISSUED FOR PERMIT
6	02/13/14	REVISED FOR PERMIT

NOVA
PROFESSIONAL ENGINEER
S.T.P. T.M.
S.T.P. T.M.
S.T.P. T.M.

115 West Beaver Creek Road, Unit 31
Richmond Hill, Ontario L4B 3M1
Tel: 905-882-5445
Fax: 905-882-5441
Email: cad@novatrendeng.com

NOVA
PROFESSIONAL ENGINEER
S.T.P. T.M.
S.T.P. T.M.
S.T.P. T.M.

PROJECT TITLE: ALEXANDRA PARK
38 CAMERON STREET, BLOCK 11
TORONTO, ONTARIO

DRAWING TITLE: 9/F SOUTH FLOOR PLAN ELECTRICAL LAYOUT

DATE: FEB. 13 1313
PROJECT NUMBER: 1313
SCALE: 1:50
DRAWING NUMBER: E-22
DATE: FEB. 13 1313
PROJECT NUMBER: 1313
SCALE: 1:50
DRAWING NUMBER: E-22