
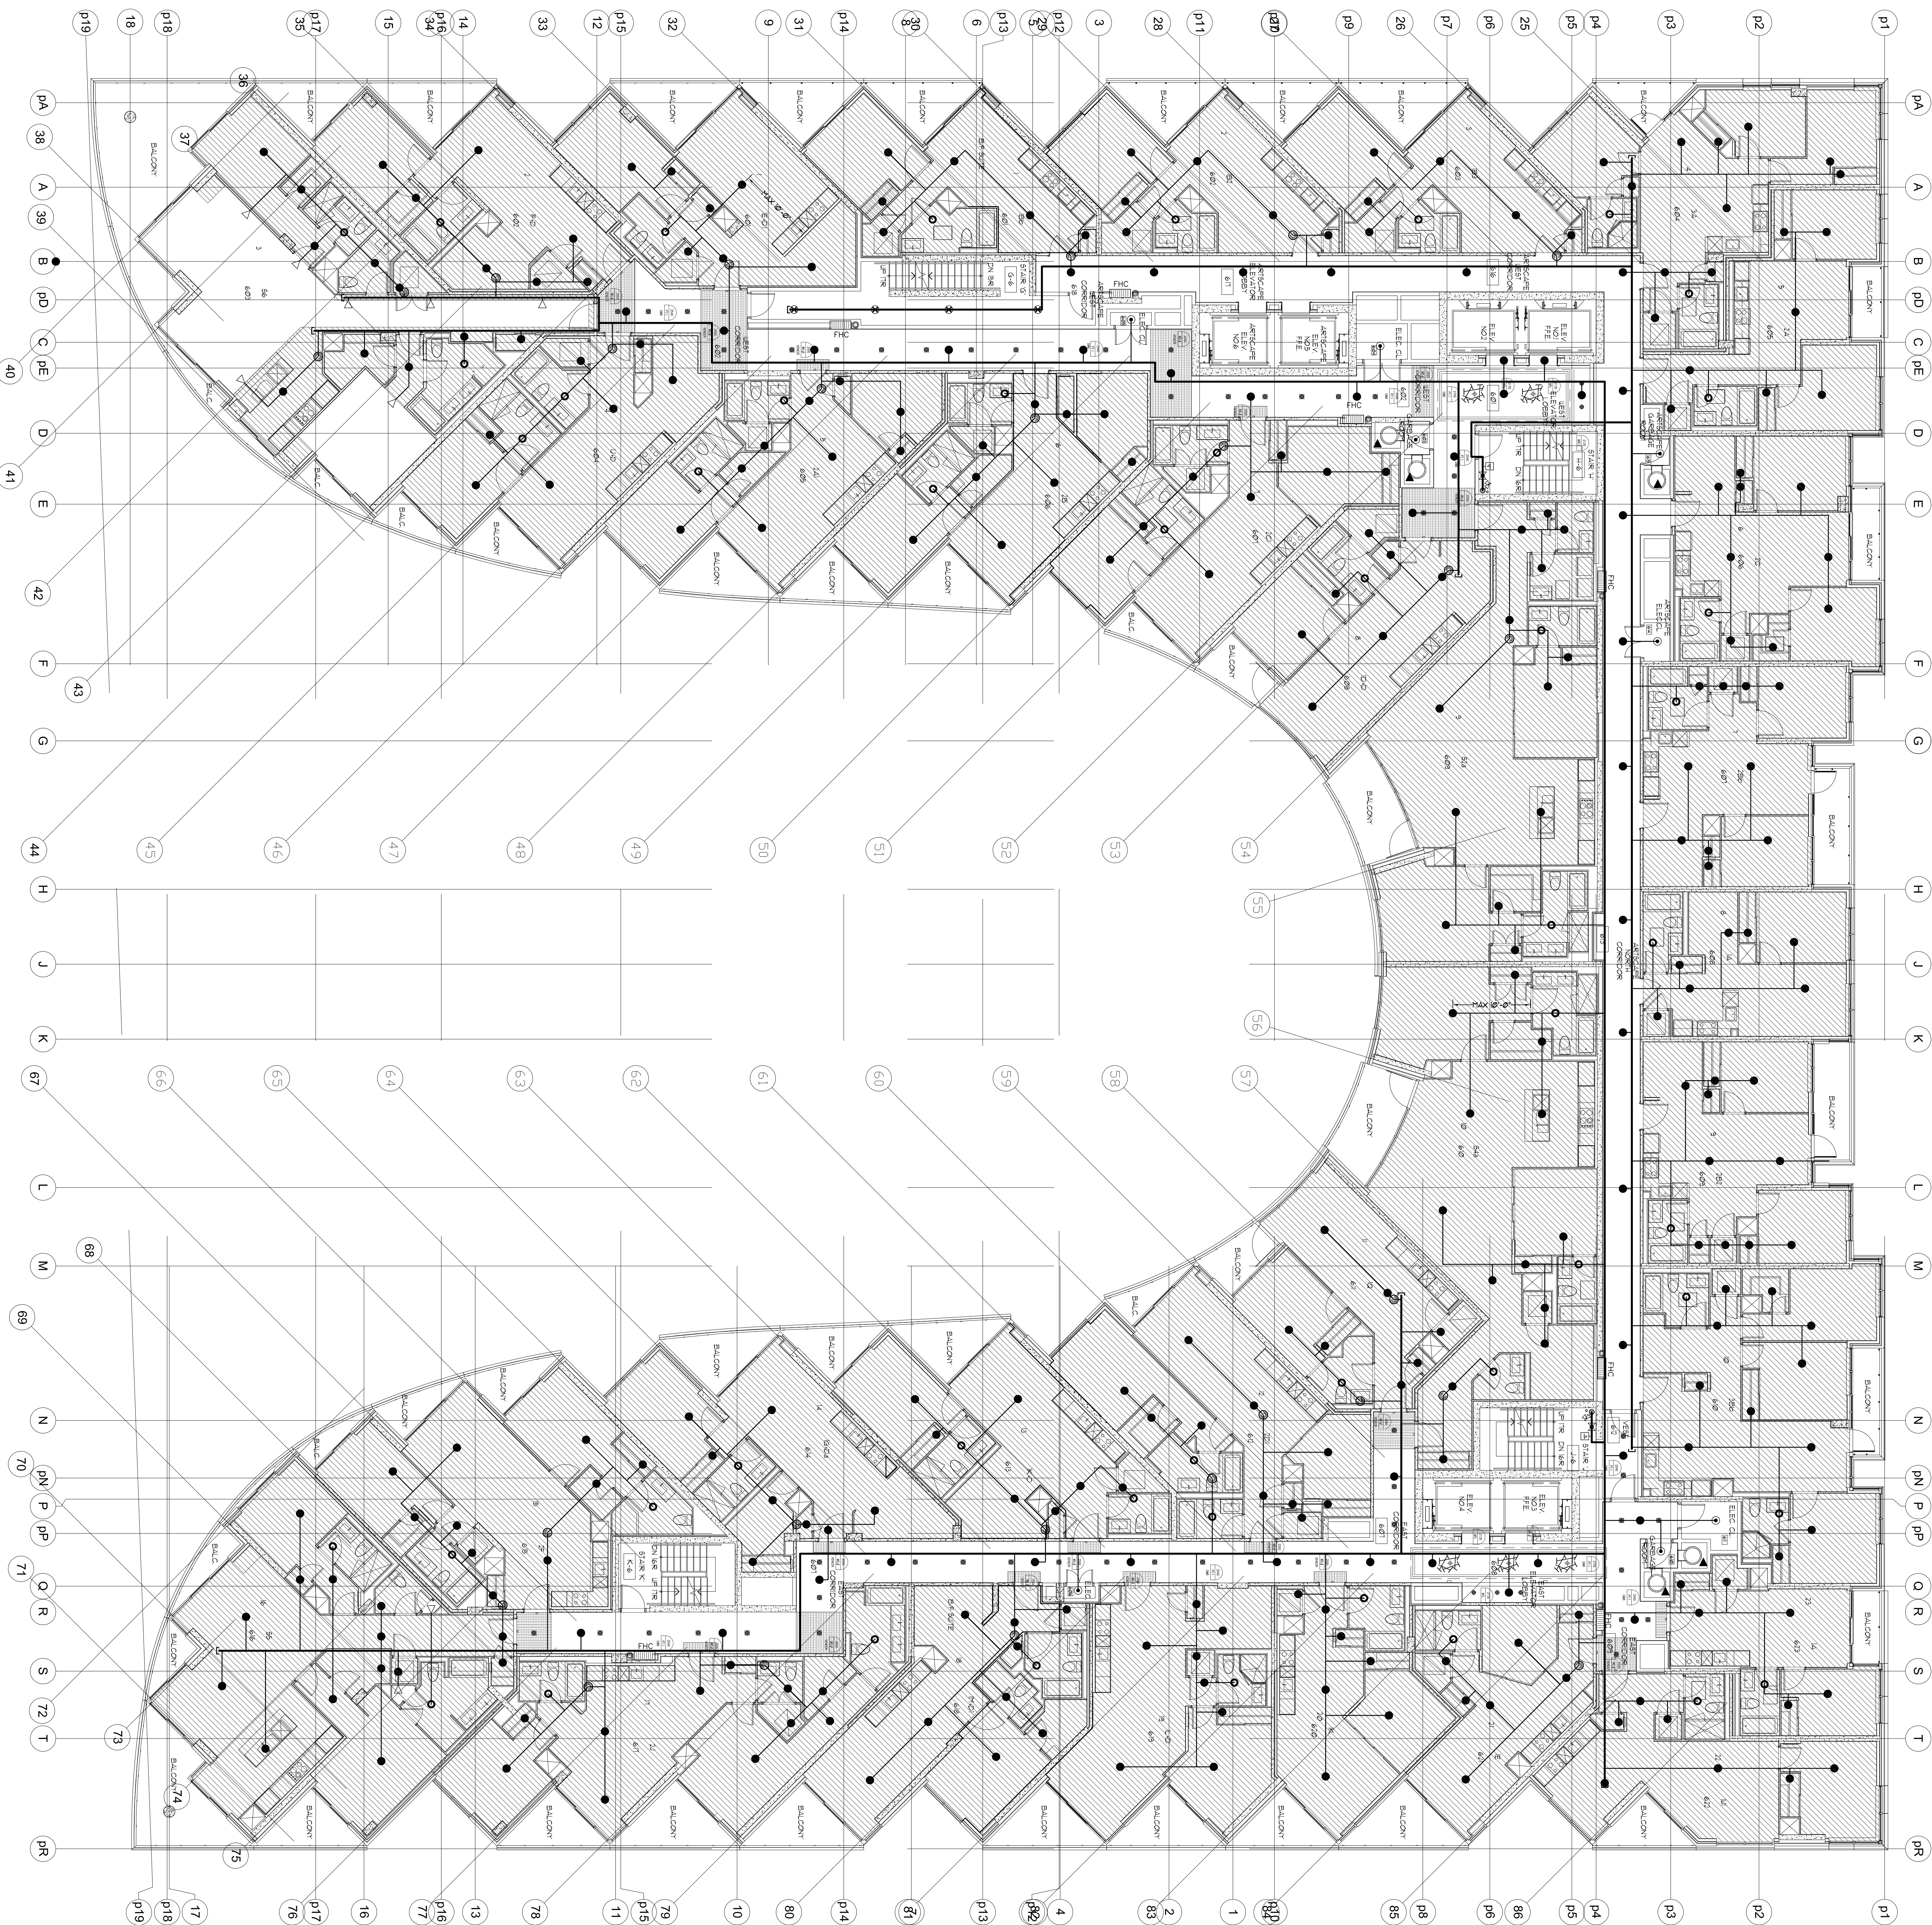


REVISIONS	
1.0	ISSUED FOR TENDER 10/15/15

NOTES

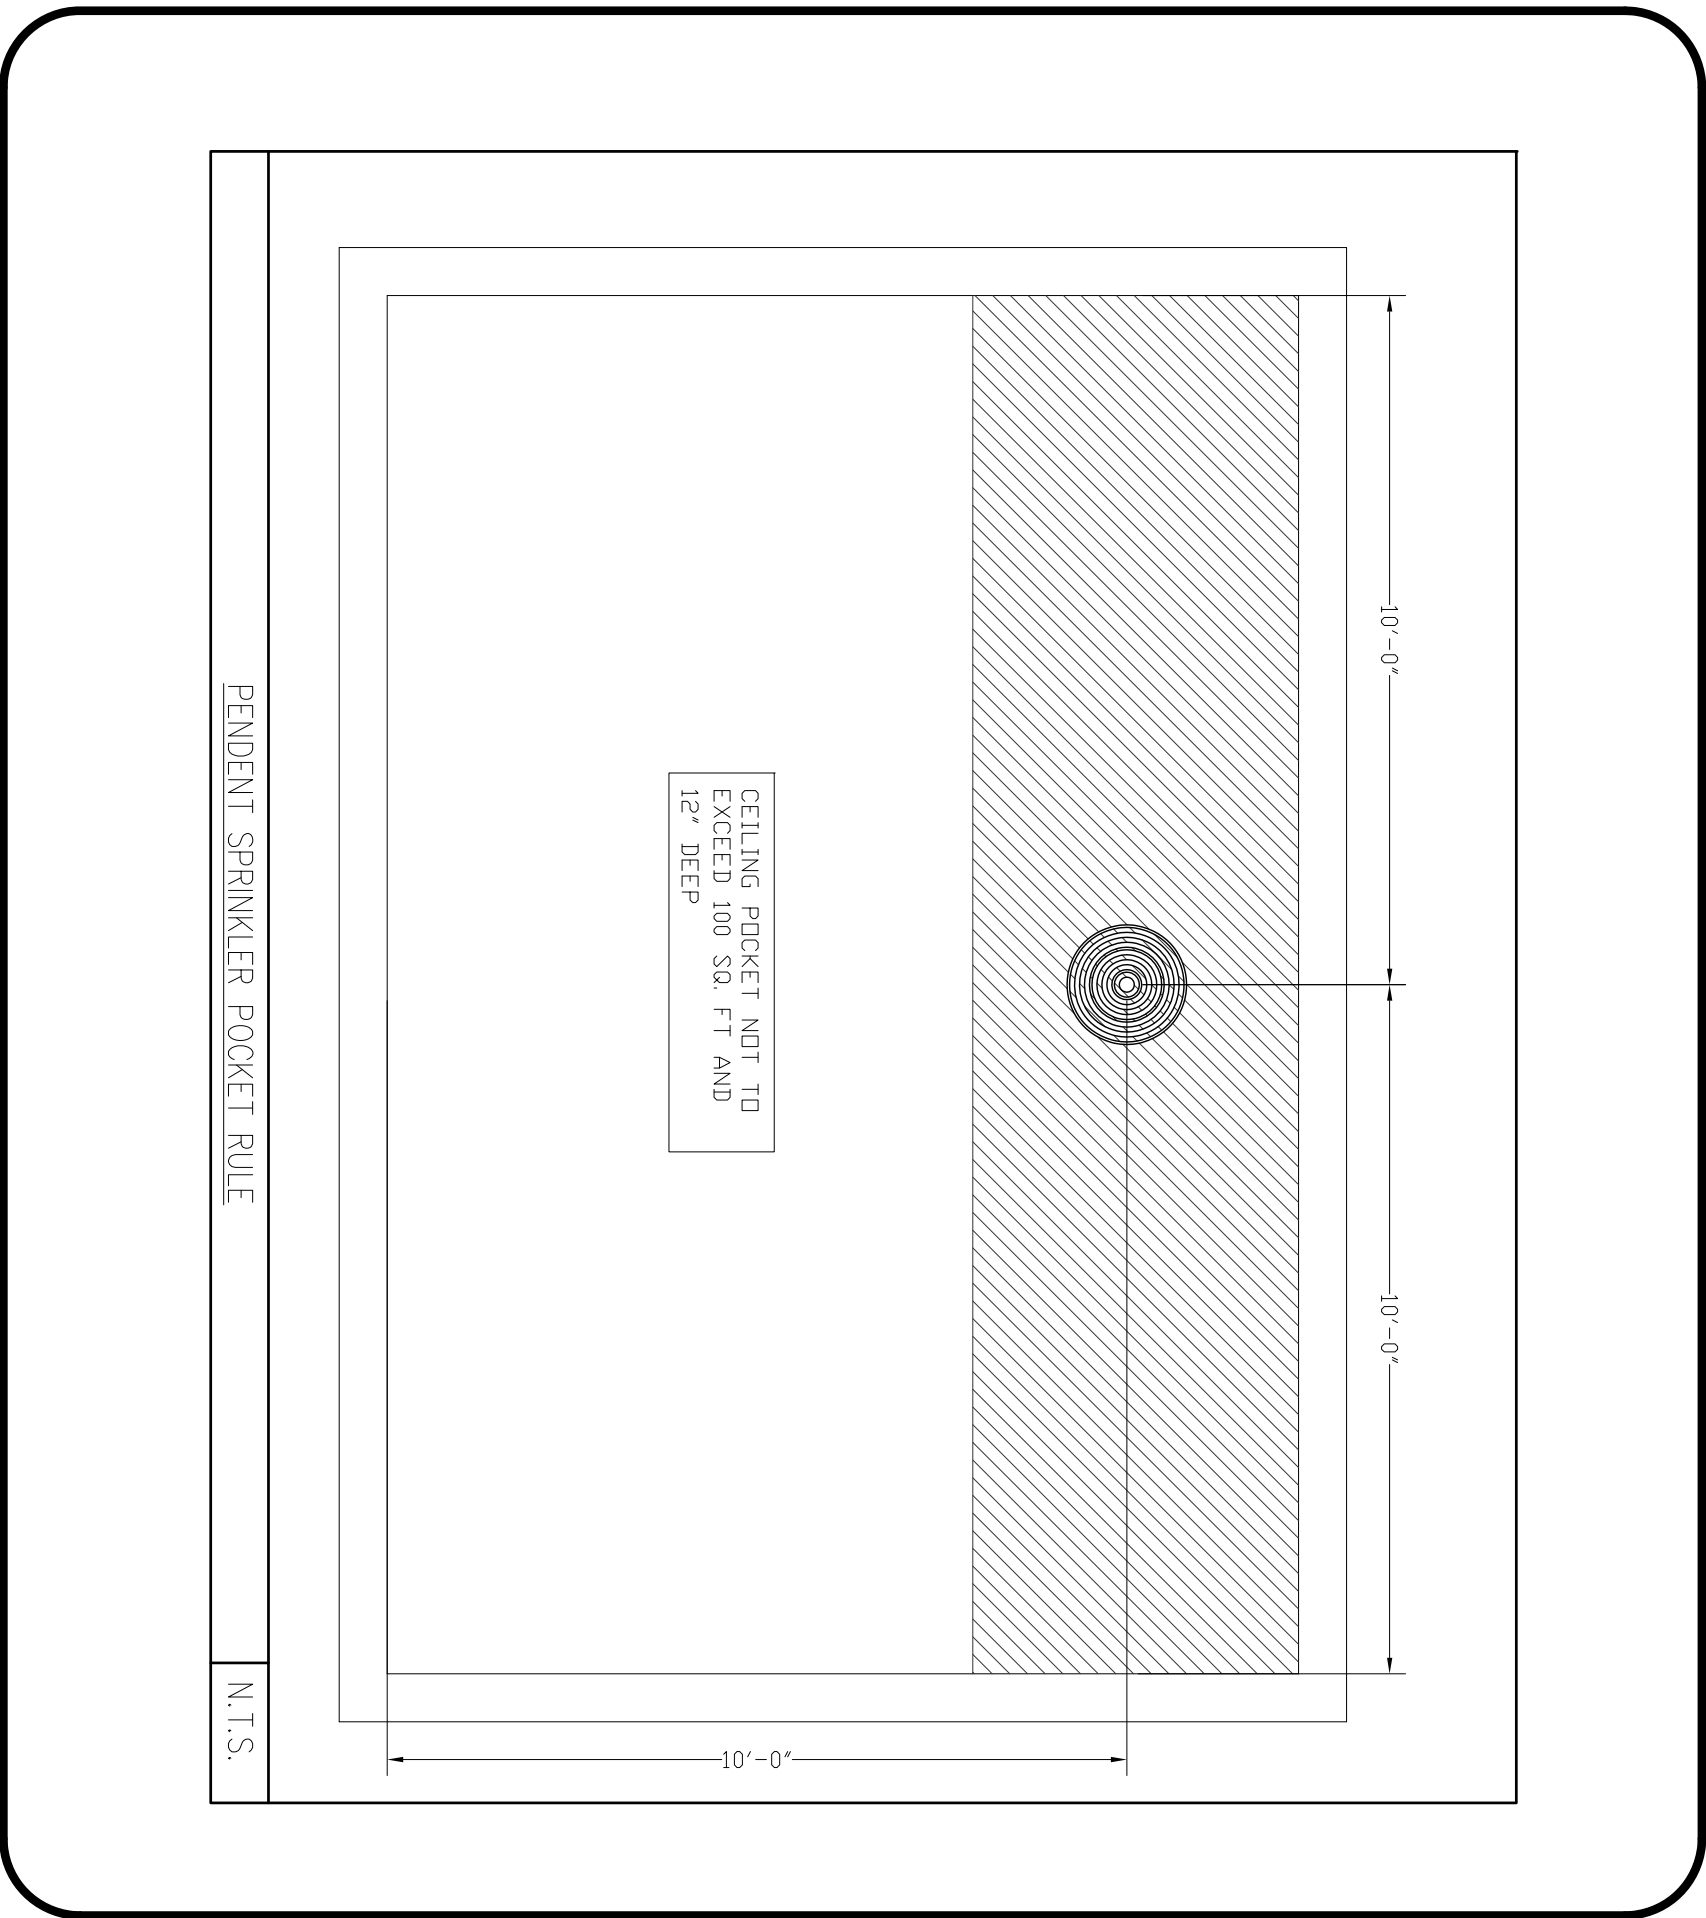


6TH FLOOR SPRINKLER LAYOUT
SCALE: 1/8"=1'-0"

1. MAXIMUM COVERAGE FOR RESIDENTIAL SPECIAL SPRINKLERS
NOMINAL FIRST BEAM SPARKING RISE TO BE 4'-0"
 2. MAXIMUM FIRST BEAM SPARKING RISE TO BE 4'-0"
 3. MAXIMUM DISTANCE FROM ANY SIDE WALL TO SPRINKLER NOT TO EXCEED 8'-0"
 4. SPECIAL SPRINKLERS SHALL BE LOCATED AT LEAST 3'-0" FROM OBSTRUCTIONS SUCH AS CEILING FANS AND LIGHT FIXTURES
 5. SEE OBSTRUCTION TABLE ON DRAWING SET
- NOTES - RESIDENTIAL PENDENT SPRINKLERS
1. MAXIMUM COVERAGE FOR RESIDENTIAL PENDENT SPRINKLERS NOT TO EXCEED 18'-0"
 2. MAXIMUM FIRST BEAM SPARKING RISE TO BE 4'-0"
 3. MAXIMUM DISTANCE FROM ANY SIDE WALL TO SPRINKLER NOT TO EXCEED 8'-0"
 4. PENDENT SPRINKLERS SHALL BE LOCATED AT LEAST 3'-0" FROM OBSTRUCTIONS SUCH AS CEILING FANS AND LIGHT FIXTURES
 5. SEE OBSTRUCTION TABLE ON DRAWING SET

[illegible]

15171 Yonge Street Suite 202
Aurora Ontario L4G 1M1
(tel): 905-727-0092
(fax): 905-727-5517

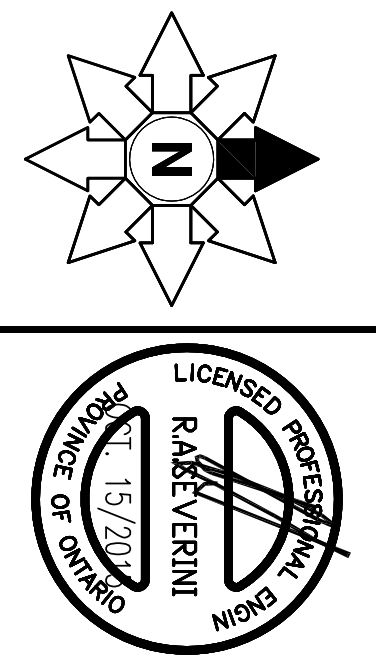

AQUAVISTA
MERCHANTS WHARF
TORONTO, ONTARIO

DWG TITLE

6TH LEVEL SPRINKLER LAYOUT	
DATE	PROJECT NO.
10/15/2015	15-678
SCALE	
1/8"=1'-0"	
DWGS BY	DWG NO.
JL	
ISSUED FOR REVISION NO.	SP11
1.0	OF SP20