


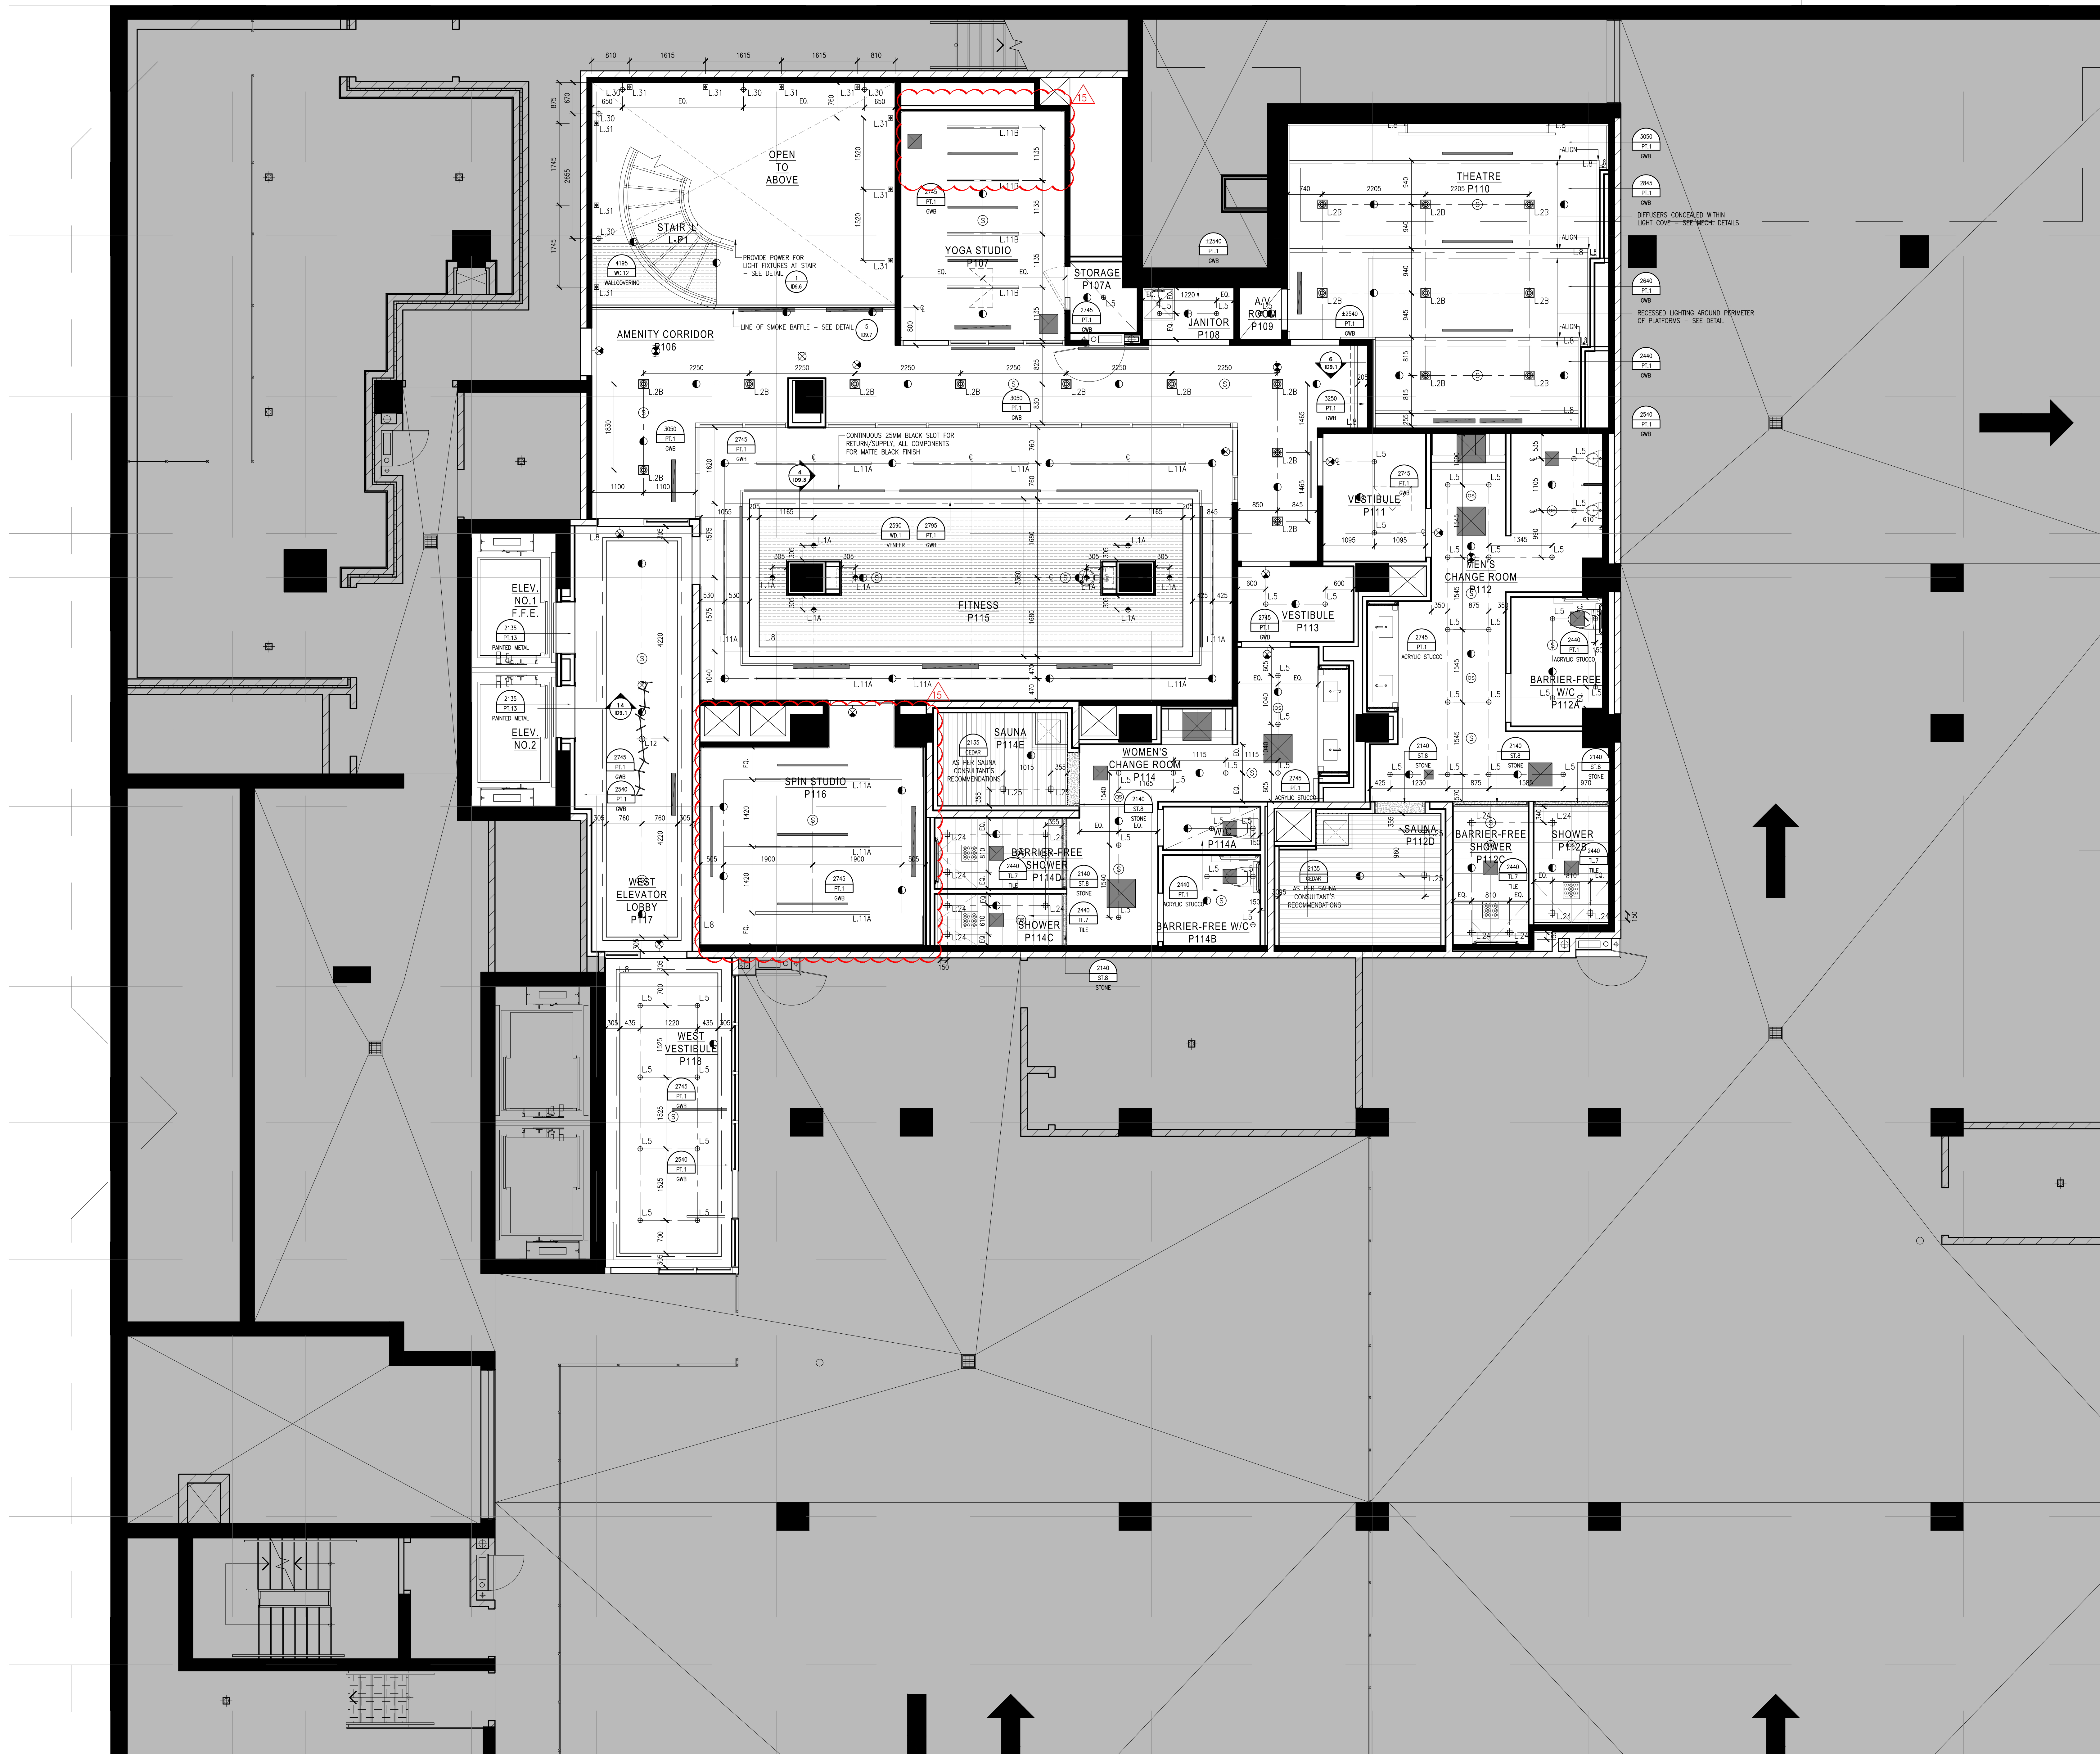

LEGEND : DRAWING SYMBOLS	
SYMBOL	DESCRIPTION
	DETAIL NUMBER REFER TO 30" X 48" DETAIL 11
	CILING HEIGHT CEILING FINISH CEILING MATERIAL REFER TO 11" X 12" PRODUCT SPECIFICATIONS
	LIGHTING CODE REFER TO 11" X 12" LIGHTING SPECIFICATIONS
	WOOD GRAIN DIRECTION
	UPRIGHT SPRINKLER CODE REFER TO CONSULTANT'S DRAWINGS FOR SPRINKLER SPECIFICATIONS & LOCATIONS
	PENDANT SPRINKLER CODE REFER TO CONSULTANT'S DRAWINGS FOR SPRINKLER SPECIFICATIONS & LOCATIONS
	SONNOL SPRINKLER CODE REFER TO CONSULTANT'S DRAWINGS FOR SPRINKLER SPECIFICATIONS & LOCATIONS
	LINEAR DIFFUSER CODE REFER TO MECHANICAL CONSULTANT'S DRAWINGS FOR SPECIFICATIONS & LOCATIONS
	RETURN AIR CODE REFER TO MECHANICAL CONSULTANT'S DRAWINGS FOR SPECIFICATIONS & LOCATIONS
	SUPPLY AIR CODE REFER TO MECHANICAL CONSULTANT'S DRAWINGS FOR SPECIFICATIONS & LOCATIONS
	EXHAUST AIR CODE REFER TO MECHANICAL CONSULTANT'S DRAWINGS FOR SPECIFICATIONS & LOCATIONS
	ACCESS PANEL CODE REFER TO MECHANICAL CONSULTANT'S DRAWINGS FOR SPECIFICATIONS & LOCATIONS
	CEILING MOUNTED SPEAKER REFER TO CONSULTANT'S DRAWINGS FOR SPECIFICATIONS & LOCATIONS
	WALL MOUNTED DIM LIGHT REFER TO CONSULTANT'S DRAWINGS FOR SPECIFICATIONS & LOCATIONS
	CEILING MOUNTED DIM LIGHT REFER TO CONSULTANT'S DRAWINGS FOR SPECIFICATIONS & LOCATIONS
	CEILING MOUNTED OCCUPANCY SENSOR REFER TO CONSULTANT'S DRAWINGS FOR SPECIFICATIONS & LOCATIONS
	CEILING OR WALL MOUNTED SMOKE DETECTOR REFER TO CONSULTANT'S DRAWINGS FOR SPECIFICATIONS & LOCATIONS

REFLECTED CEILING NOTES

- MECHANICAL AND ELECTRICAL WORK TO COMPLY WITH THE REQUIREMENTS OF THE BUILDING LAWS AND NOTIFY DESIGNER HAVING COMPETENCE.
- TO DESIGNER DRAWINGS FOR LOCATION OF CEILING FIXTURES, FIXTURES TO CONFORMING DRAWINGS FOR SPECIFICATIONS.
- CONTRACTOR TO CROSS REFERENCE BETWEEN DESIGNER'S ELECTRICAL DRAWINGS, MECHANICAL DRAWINGS AND SITE CONDITIONS, REPORT DISCREPANCIES TO THE DESIGNER FOR CLARIFICATION.
- CONTRACTOR TO PROVIDE CORDS IN SPINNALE CABLE TO ACCOMMODATE ELECTRICAL AND CONTROL CABLES, REDUCED CORD LENGTHS, AND SURPLUS. CONTRACTOR TO REPORT TO REFLECTED CEILING PLAN AND ENGINEERING DRAWINGS AND DESIGNER.
- LIGHT FIXTURES AND SWITCHES TO BE LOCATED IN ACCORDANCE WITH DESIGNER DRAWINGS, REPORT DISCREPANCIES TO THE DESIGNER PRIOR TO INSTALLATION.
- CONTRACTOR TO PROVIDER AIR TRANSFER CLOSERS IN ACCORDANCE WITH MECHANICAL DRAWINGS, WHERE CONSTRUCTION OCCURS ABOVE SUSPENDED CEILING TO AVOID OF SLAB.
- TO REPORT TO ENGINEERING DRAWINGS FOR LIFE, SAFETY SYSTEMS.
- ELECTRICAL CONSULTANT TO OBTAIN QUANTITY AND LOCATION OF LUMINAIRE: REFERENCE TO THE LUMINAIRE SCHEDULE AND DISTRIBUTION AS REQUIRED BY LOCAL CODES AND REGULATIONS.
- ALL LIGHT FIXTURES TO BE ON OWNERS.
- CONTRACTOR TO CONFIRM CEILING HEIGHT A CONDITIONS AND NOTIFY DESIGNER OF ANY DISCREPANCIES.
- CONTRACTOR TO LIGHTING SCHEDULE TO VERIFY QUANTITY OF FIXTURES PRIOR TO ORDERING AND INSTALLING.

Notes:	
1.	CONTRACTOR AND ALL SUB-TRADES SHALL VERIFY ALL DIMENSIONS, ALL DRAWINGS, DETAILS AND SPECIFICATIONS AND REPORT ANY DISCREPANCIES TO THE INTERIOR DESIGNER IN WRITING FOR CORRECTION PRIOR TO PROCEEDING WITH THE WORK.
2.	CONTRACTOR AND SUB-CONTRACTORS, BEFORE PROCEEDING WITH WORK, MUST SUBMIT ALL MATERIALS AND FINISHES FOR APPROVAL OF QUALITY AND FINISH TO THE INTERIOR DESIGNER.
3.	CONTRACTOR MUST COMPLY WITH THE CONTRACT DOCUMENTS, PERFORMANCE REQUIREMENTS, APPLICABLE CODES AND REGULATIONS.
4.	ALL DRAWINGS AND WRITTEN MATERIAL, HEREIN OR OTHERWISE, SHALL BE THE PROPERTY OF THE WORK OF "I BY DESIGN ASSOCIATES INC." AND SHALL REMAIN THE PROPERTY OF OR DISCLOSED WITHOUT THE WRITING CONSENT OF "I BY DESIGN ASSOCIATES INC."
5.	DRAWINGS NOT TO BE SCALED
ISSUE	
01	ISSUED FOR COORDINATION 15.04.09
02	ISSUED FOR COORDINATION 15.04.11
03	ISSUED FOR COORDINATION 15.04.13
04	ISSUED FOR COORDINATION 15.04.13
05	ISSUED FOR CLIENT REVIEW 16.03.15
06	ISSUED FOR CLIENT REVIEW 16.03.15
07	ISSUED FOR TENDER 16.03.15
08	ISSUED FOR ADDENDUM 16.03.20
09	ISSUED FOR ADDENDUM 17.01.27
10	ISSUED FOR CONSTRUCTION 17.06.19
13	SITE INSTRUCTION #03 17.11.10
14	SITE INSTRUCTION #04 18.03.07
15	SITE INSTRUCTION #05 18.04.05

1 REFLECTED CEILING PLAN
103.4 SCALE 1:50