

PART 1, PLAN 66R-XXXXX

(P5&M) N64°01'10"E (P5&M) 41.000

Contractor Must Check And Verify All Dimensions On The Job.
Do Not Scale The Drawings.
All Drawings, Specifications And Related Documents Are The Copyright Of The Architect And Must Be Returned Upon Request.
Reproduction Of Drawings, Specifications And Related Documents In Part Or Whole Is Forbidden Without The Architects Written Permission.
This Drawing Is Not To Be Used For Construction Until Signed By The Architect.
Date:

Janet Rosenberg & Studio
Landscape Architecture and Urban Design
t 416 656 6655 f 416 656 5756 www.jrstudio.ca
148 Kenwood Avenue, Toronto Ontario M6C 2S3 Canada

PIN 21384

ASSUMED LOCATION OF IRRIGATION SHUT OFF VALVE / CHAMBER (YET TO BE DESIGN BY OTHERS / WATERFRONT TORONTO)

IRRIGATION CONTROLLER 2A
NON POTABLE WATER / CISTERN
AQUAVISTA TO PROVIDE 1" WATER SUPPLY TO THIS CHAMBER ACCOMPANIED BY A 1" CONDUIT FOR IRRIGATION WIRE

IRRIGATION CONTROLLER 1
POTABLE WATER
AQUAVISTA TO PROVIDE 1" WATER SUPPLY TO THIS CHAMBER ACCOMPANIED BY A 1" CONDUIT FOR IRRIGATION WIRE

ADDITIONAL IRRIGATION REQUIREMENTS
IRRIGATION CONTROLLER 1 - POWER / MECHANICAL ROOM LOCATION
IRRIGATION CONTROLLER 2A - POWER / MECHANICAL ROOM LOCATION
IRRIGATION CONTROLLER 2B - POWER / MECHANICAL ROOM LOCATION

IRRIGATION CONTROLLER 1
POTABLE WATER
AQUAVISTA TO PROVIDE 1" WATER SUPPLY TO THIS CHAMBER ACCOMPANIED BY A 1" CONDUIT FOR IRRIGATION WIRE

ASSUMED LOCATION OF EXISTING IRRIGATION SHUT OFF VALVES
INSIDE EXISTING CHAMBERS - DESIGNED AND INSTALLED BY OTHERS
REFER TO IRRIGATION DRAWINGS PREPARED FOR WATERFRONT TORONTO BY SMART WATERING SYSTEMS

IRRIGATION COORDINATION
JRS - 150513


No.	Revision	Date
1.	Issued for Site Plan Approval to WT	15.01.30
2.	Issued for Site Plan Approval	15.03.04




Drawing Title
**Landscape Layout
Ground Floor**

Project
Hines TRIDEL

Aquavista
BAYSIDE, TORONTO
Scale
1:200
Drawn by
LP/ CP
Checked by
RB
Project No.
14-117
Date
06/03/14

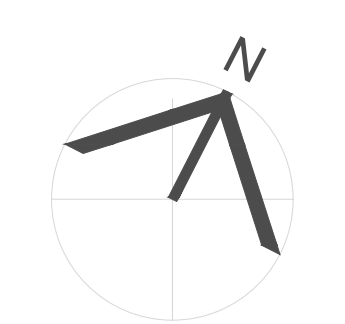

Drawing No.
L-201

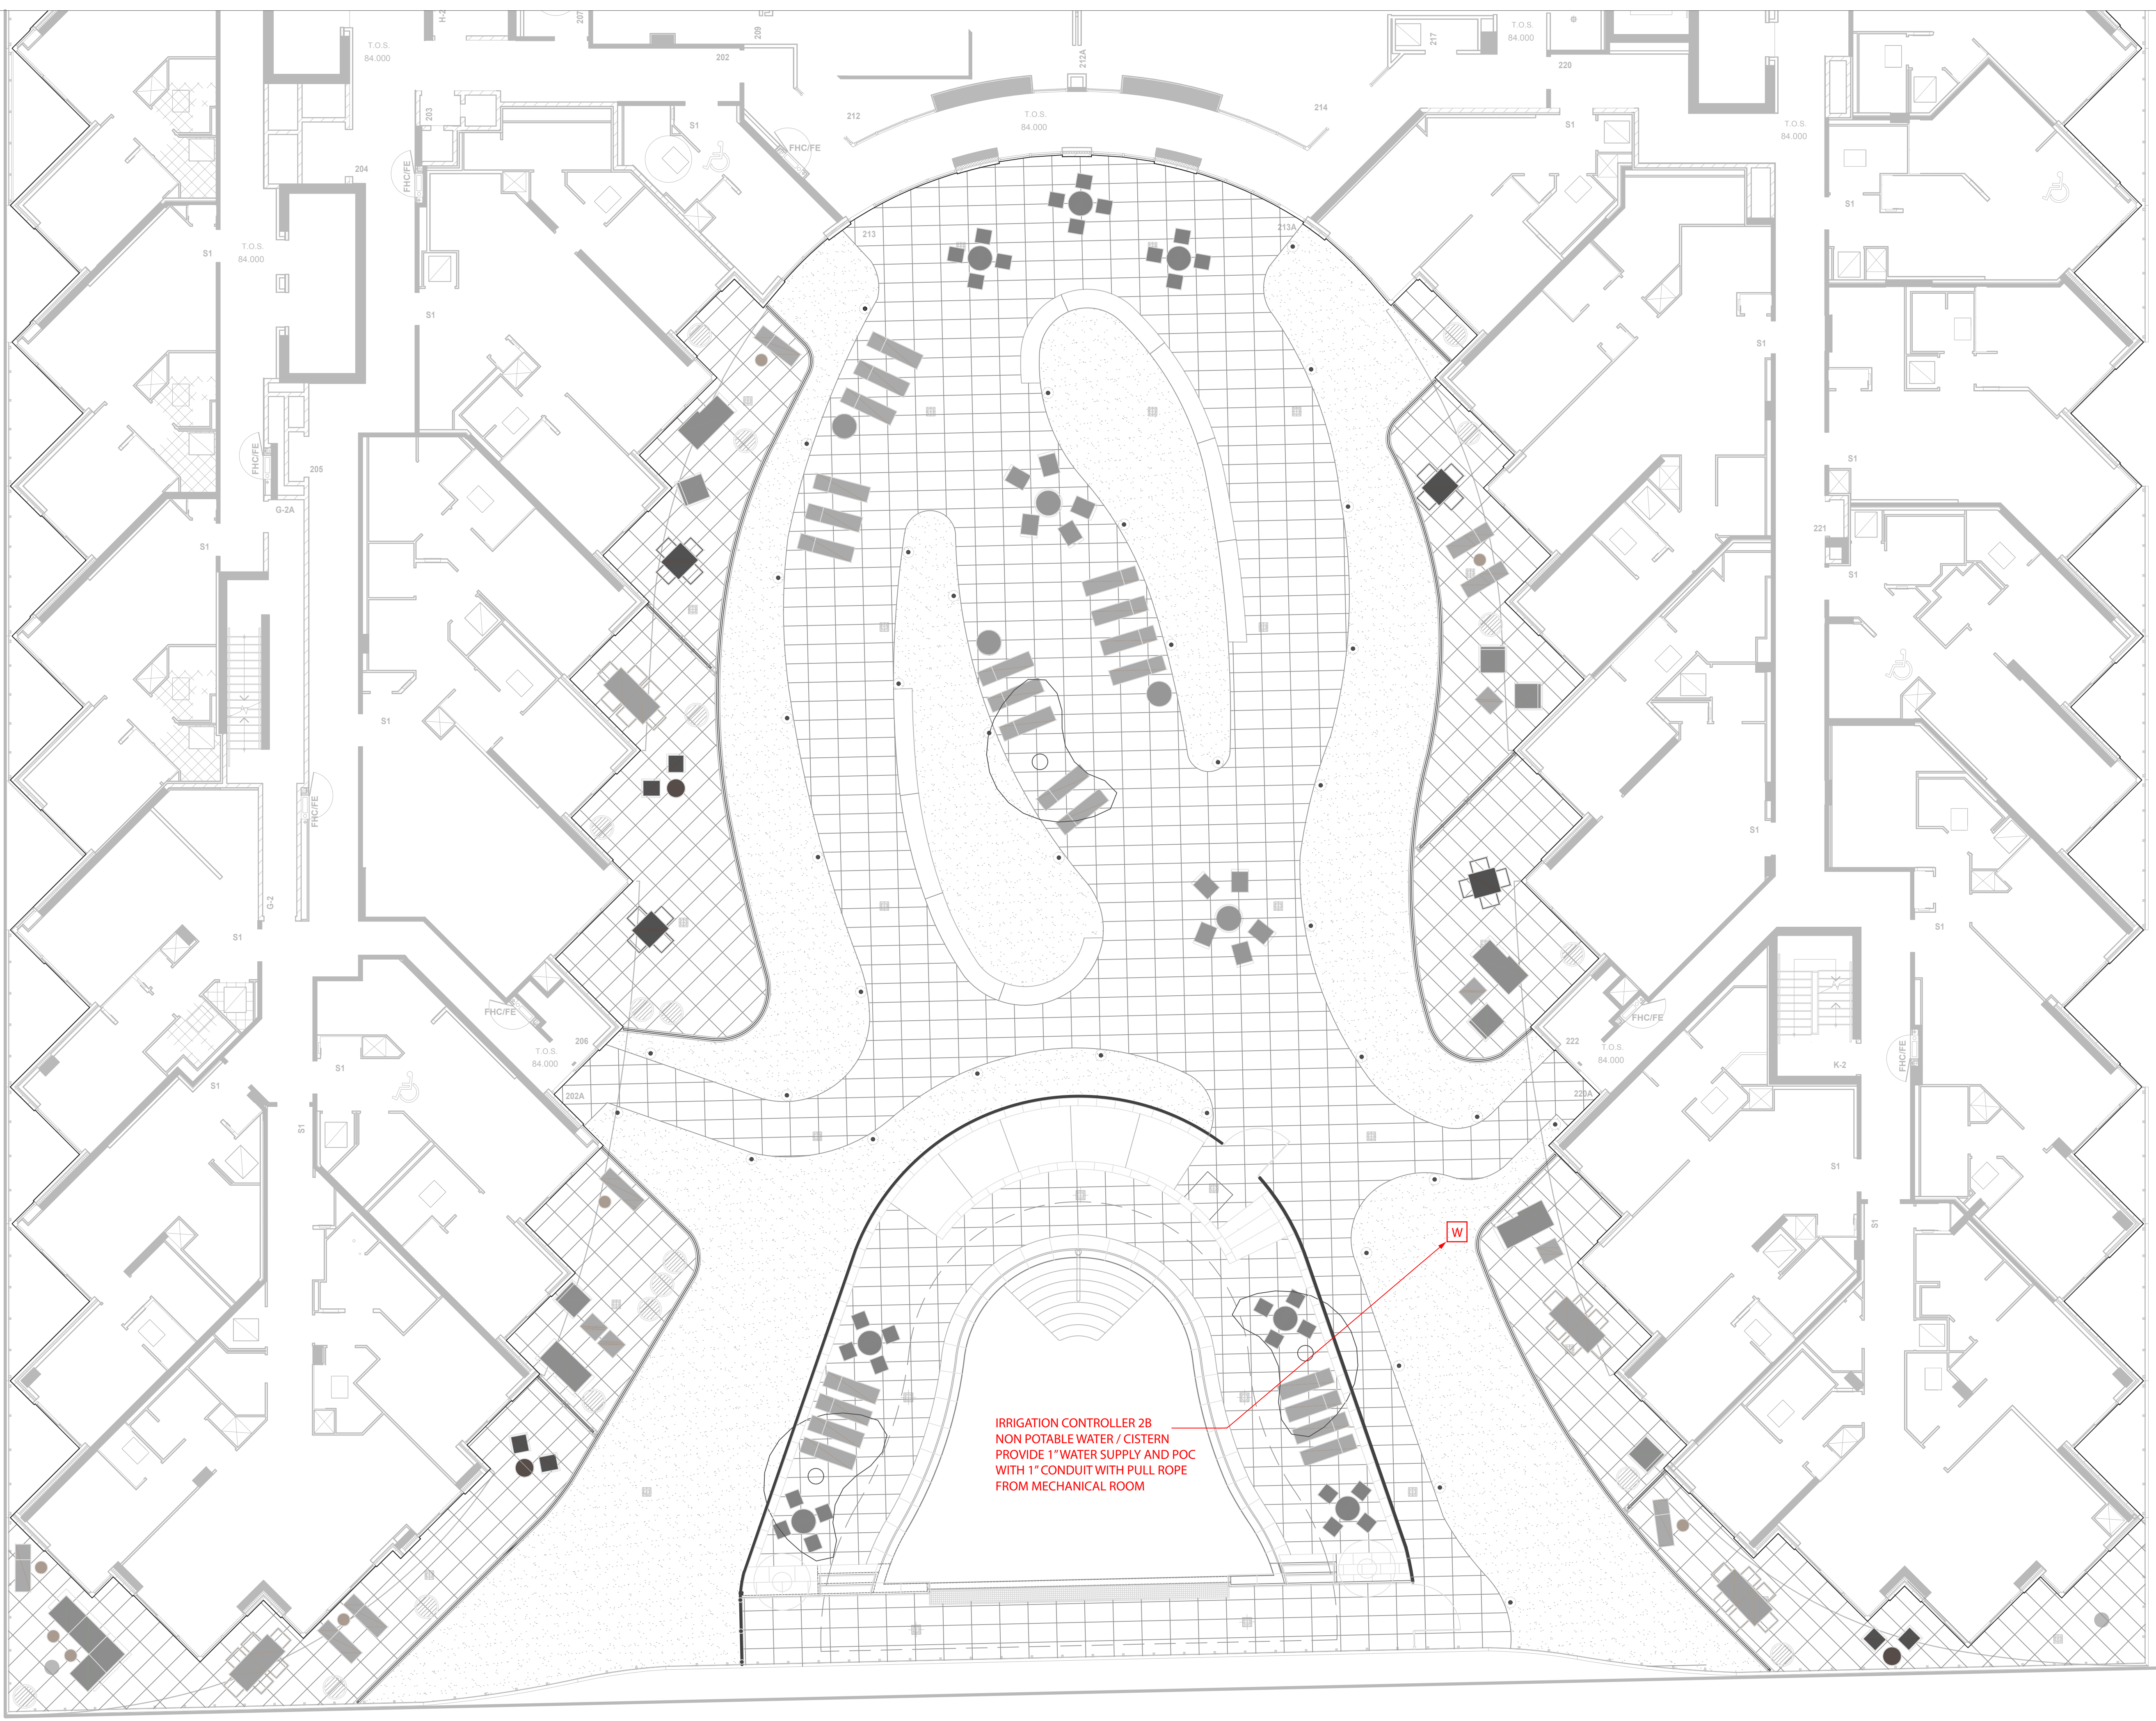

Contractor Must Check And Verify All Dimensions On The Job Do Not Scale The Drawings.
 All Drawings, Specifications And Related Documents Are The Copyright Of The Architect And Must Be Returned Upon Request.
 Reproduction Of Drawings, Specifications And Related Documents In Part Or Whole Is Forbidden Without The Architects Written Permission.
 This Drawing Is Not To Be Used For Construction Until Signed By The Architect.
 Date:

PROGRESS
 APRIL 24, 2015

No.	Revision	Date
1.	Issued for Site Plan Approval to WT	15.01.30
2.	Issued for Site Plan Approval	15.03.04



Drawing Title

Landscape Layout
 Amenity Level
 (2nd Floor)
 OPTION 1

Project

Hines TRIDEL

Aquavista

BAYSIDE, TORONTO

Scale

1 : 100

Drawn by CP/LP/RB


Checked by RB


Project No. 14-117

Date 06/03/14

Drawing No.

L-202

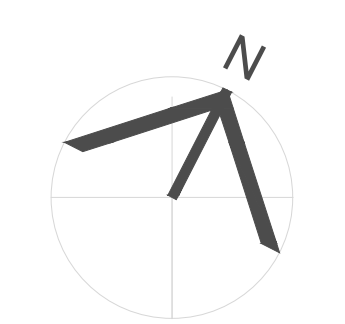


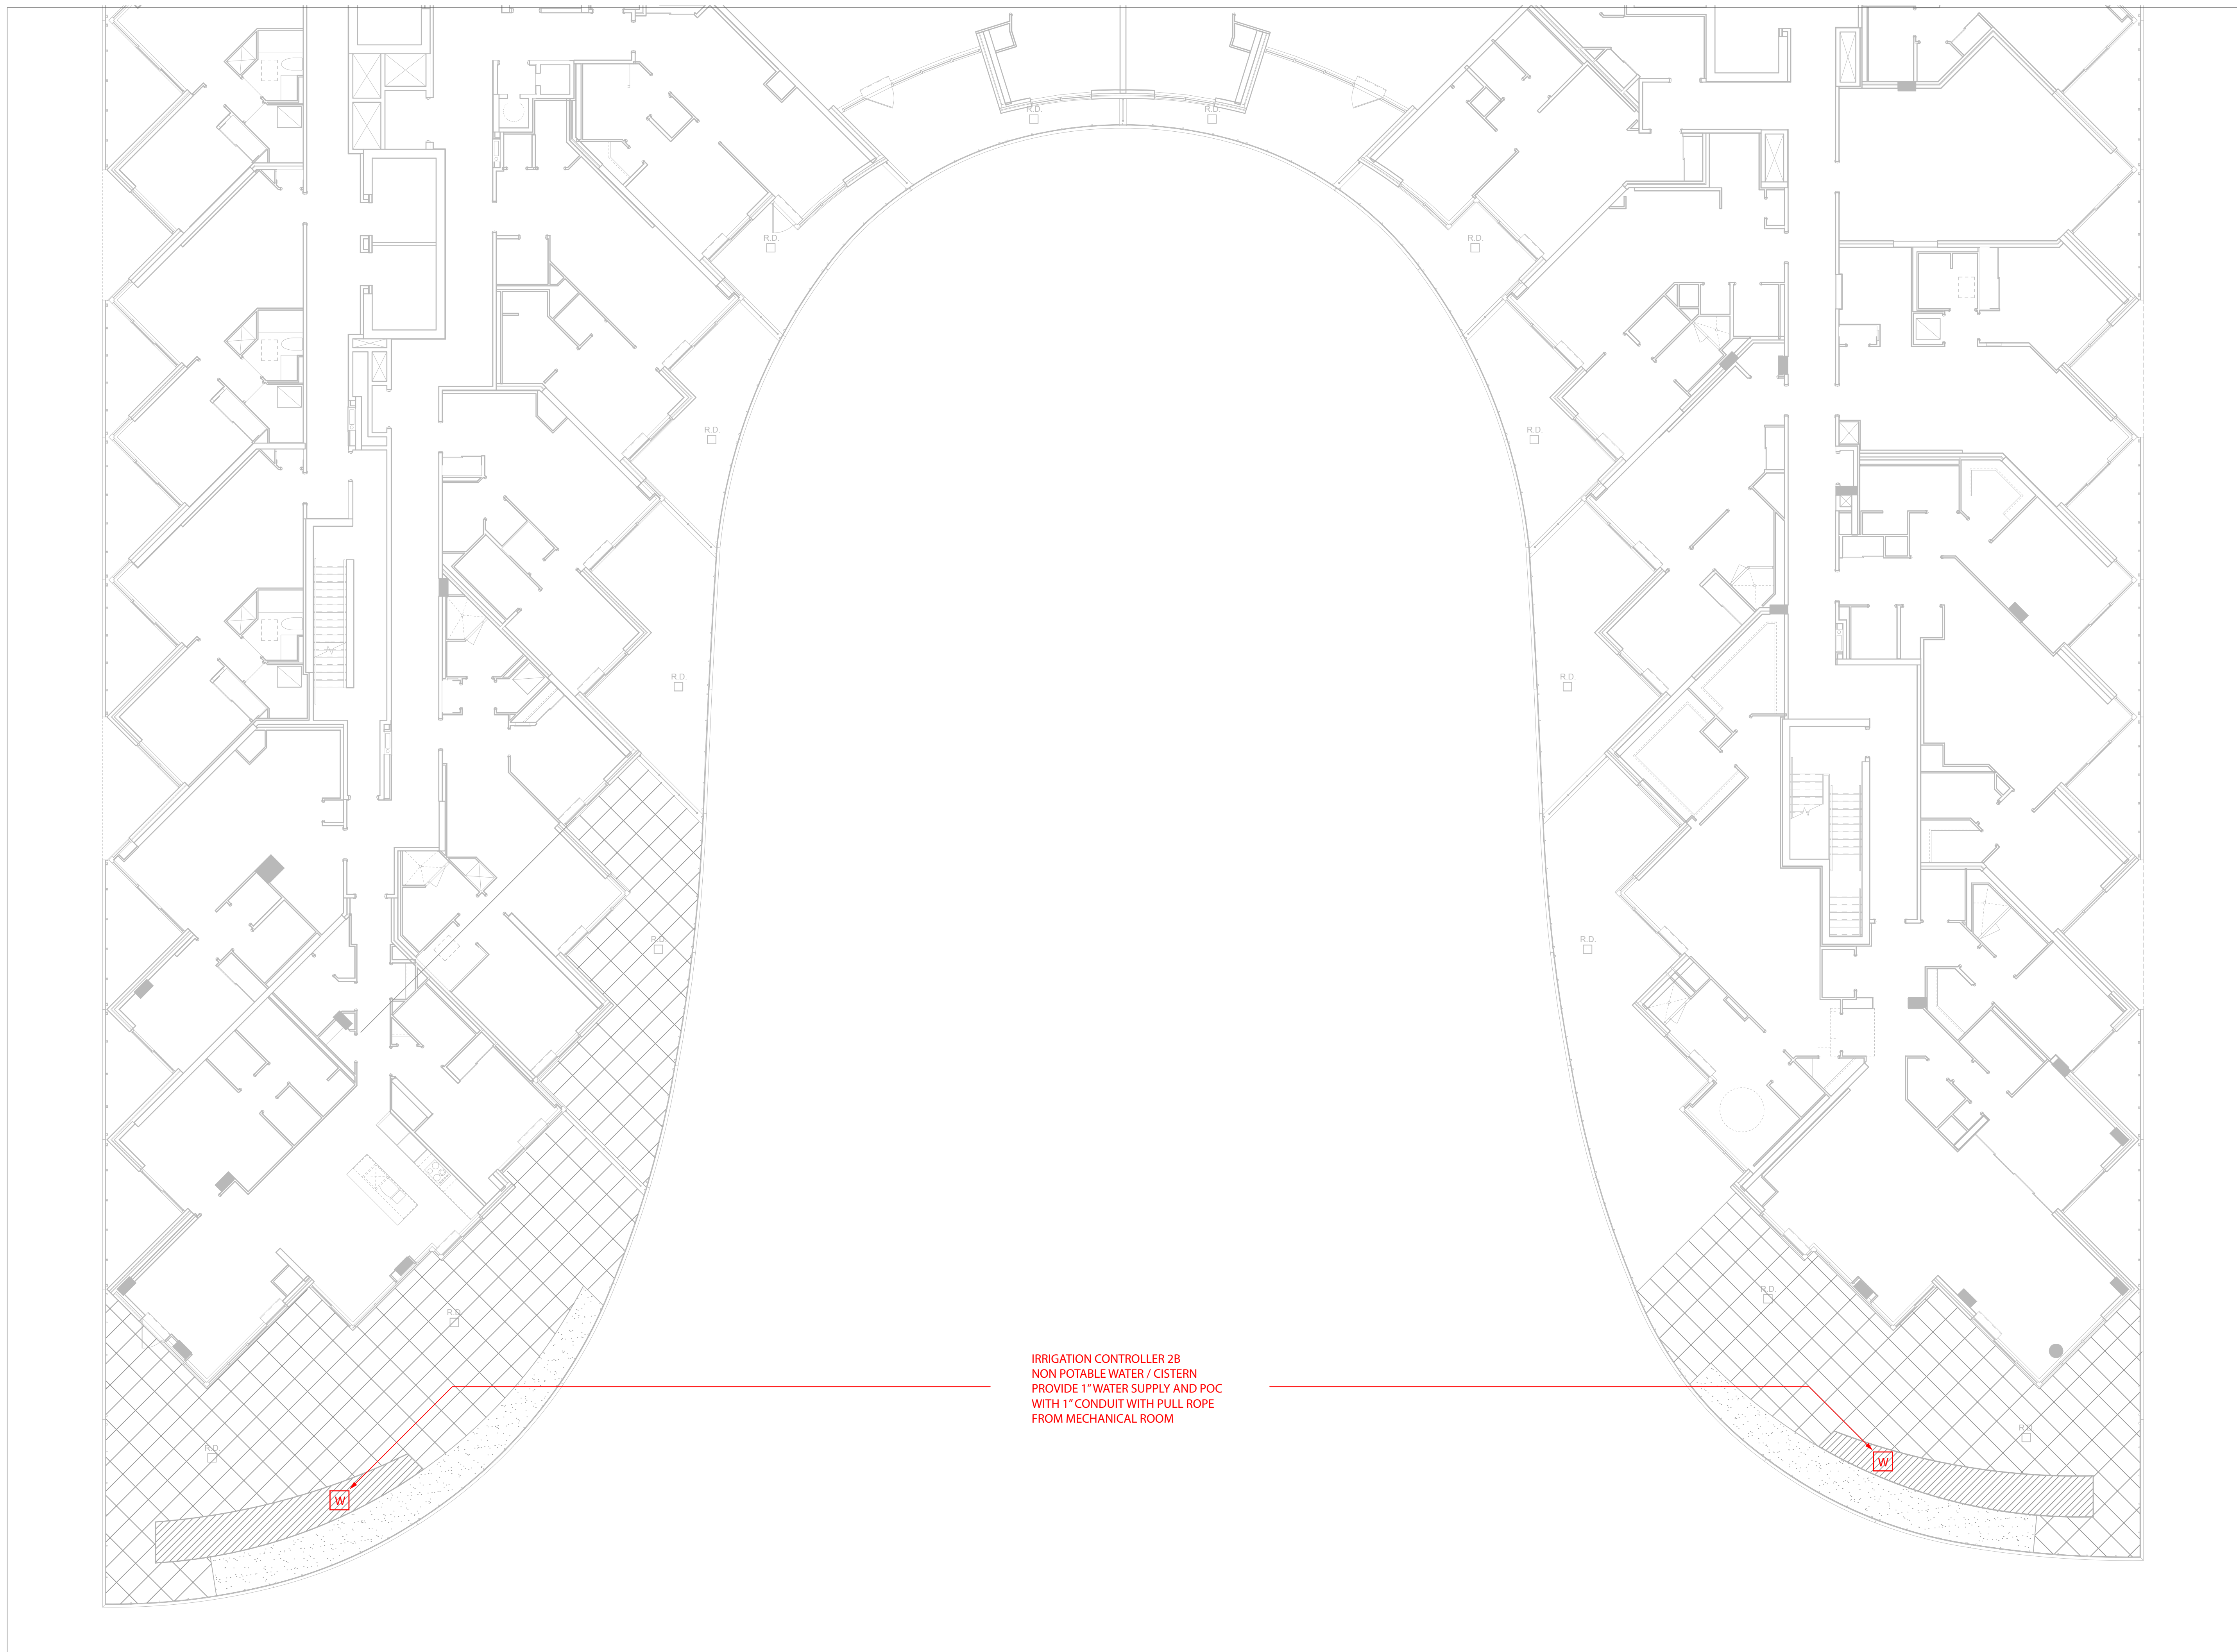

IRRIGATION CONTROLLER 2B
 NON POTABLE WATER / CISTERN
 PROVIDE 1" WATER SUPPLY AND POC
 WITH 1" CONDUIT WITH PULL ROPE
 FROM MECHANICAL ROOM

Contractor Must Check And Verify All Dimensions On The Job.
 Do Not Scale The Drawings.
 All Drawings, Specifications And Related Documents Are The
 Copyright Of
 The Architect And Must Be Returned Upon Request.
 Reproduction Of Drawings, Specifications And Related Documents
 In Part Or Whole Is Forbidden Without The Architects Written
 Permission.
 This Drawing Is Not To Be Used For Construction Until Signed
 By The Architect.
 Date:

No.:	Revision	Date
1.	Issued for Site Plan Approval to WT	15.01.30
2.	Issued for Site Plan Approval	15.03.04

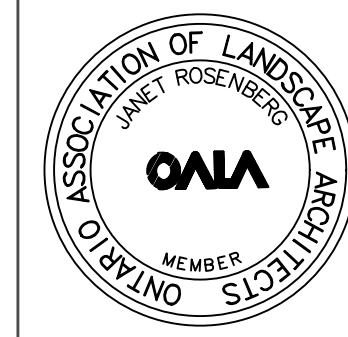

Drawing
 Title

Landscape Layout
 7th Floor

Project

Hines TRIDEL

Aquavista

BAYSIDE, TORONTO
 Scale

1 : 100

Drawn
 by

CP

Checked
 by

RB

Project
 No.


14-117


Date

12/05/14

Drawing
 No.

L-207

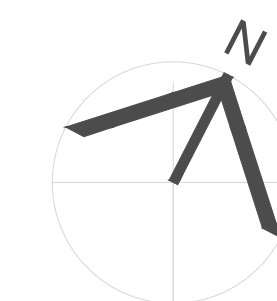

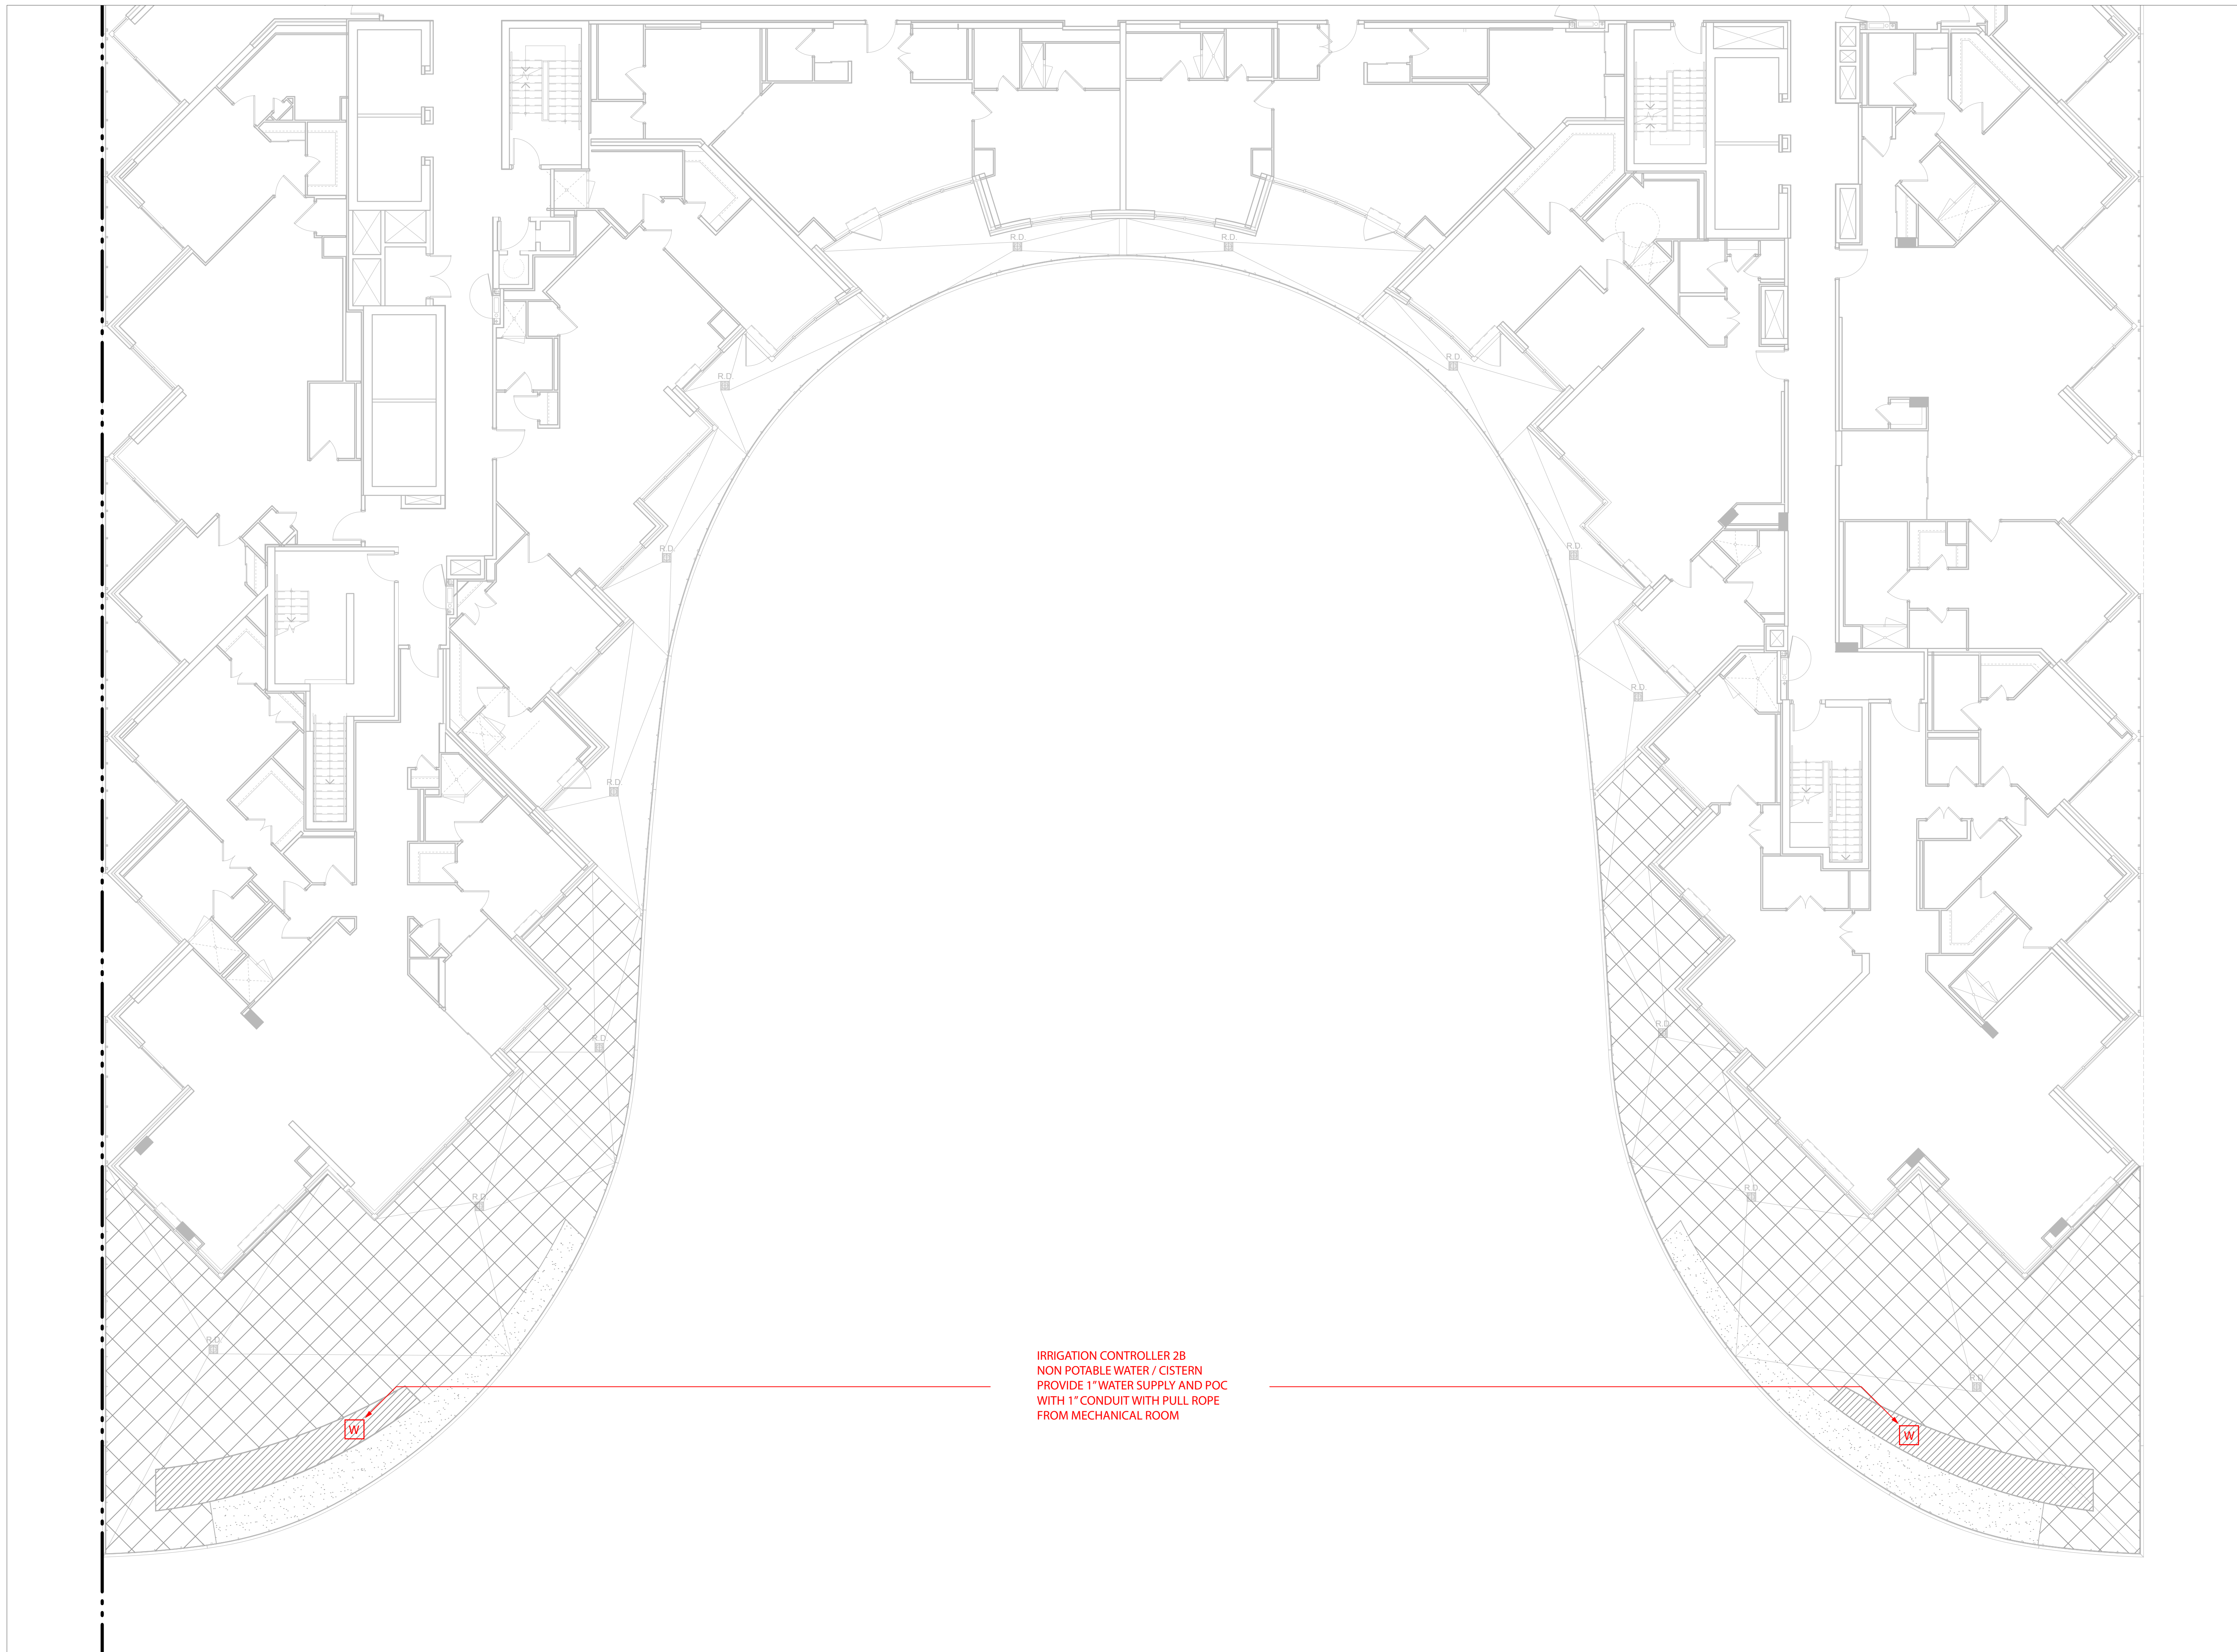

IRRIGATION CONTROLLER 2B
 NON POTABLE WATER / CISTERN
 PROVIDE 1" WATER SUPPLY AND POC
 WITH 1" CONDUIT WITH PULL ROPE
 FROM MECHANICAL ROOM

Contractor Must Check And Verify All Dimensions On The Job.
 Do Not Scale The Drawings.
 All Drawings, Specifications And Related Documents Are The
 Copyright Of
 The Architect And Must Be Returned Upon Request.
 Reproduction Of Drawings, Specifications And Related Documents
 In Part Or Whole Is Forbidden Without The Architects Written
 Permission.
 This Drawing Is Not To Be Used For Construction Until Signed
 By The Architect.
 Date:

**Janet
 Rosenberg
 & Studio**
 Landscape Architecture and Urban Design
 t 416 656 6665 f 416 656 5756 www.jrstudio.ca
 148 Kenwood Avenue, Toronto Ontario M6G 2S3 Canada


No.:	Revision	Date
1.	Issued for Site Plan Approval to WT	15.01.30
2.	Issued for Site Plan Approval	15.03.04




Drawing
 Title
**Landscape Layout
 11th Floor**

Project
Hines TRIDEL

Aquavista
 BAYSIDE, TORONTO
 Scale
 1 : 100
 Drawn by
 CP
 Checked by
 RB
 Project No.
 14-117
 Date
 12/05/14

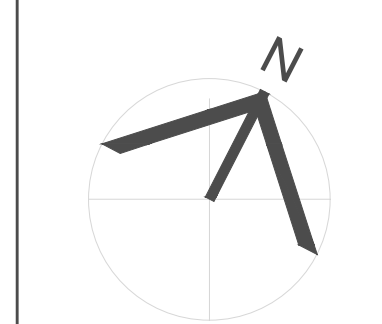

Drawing
 No.
L-211

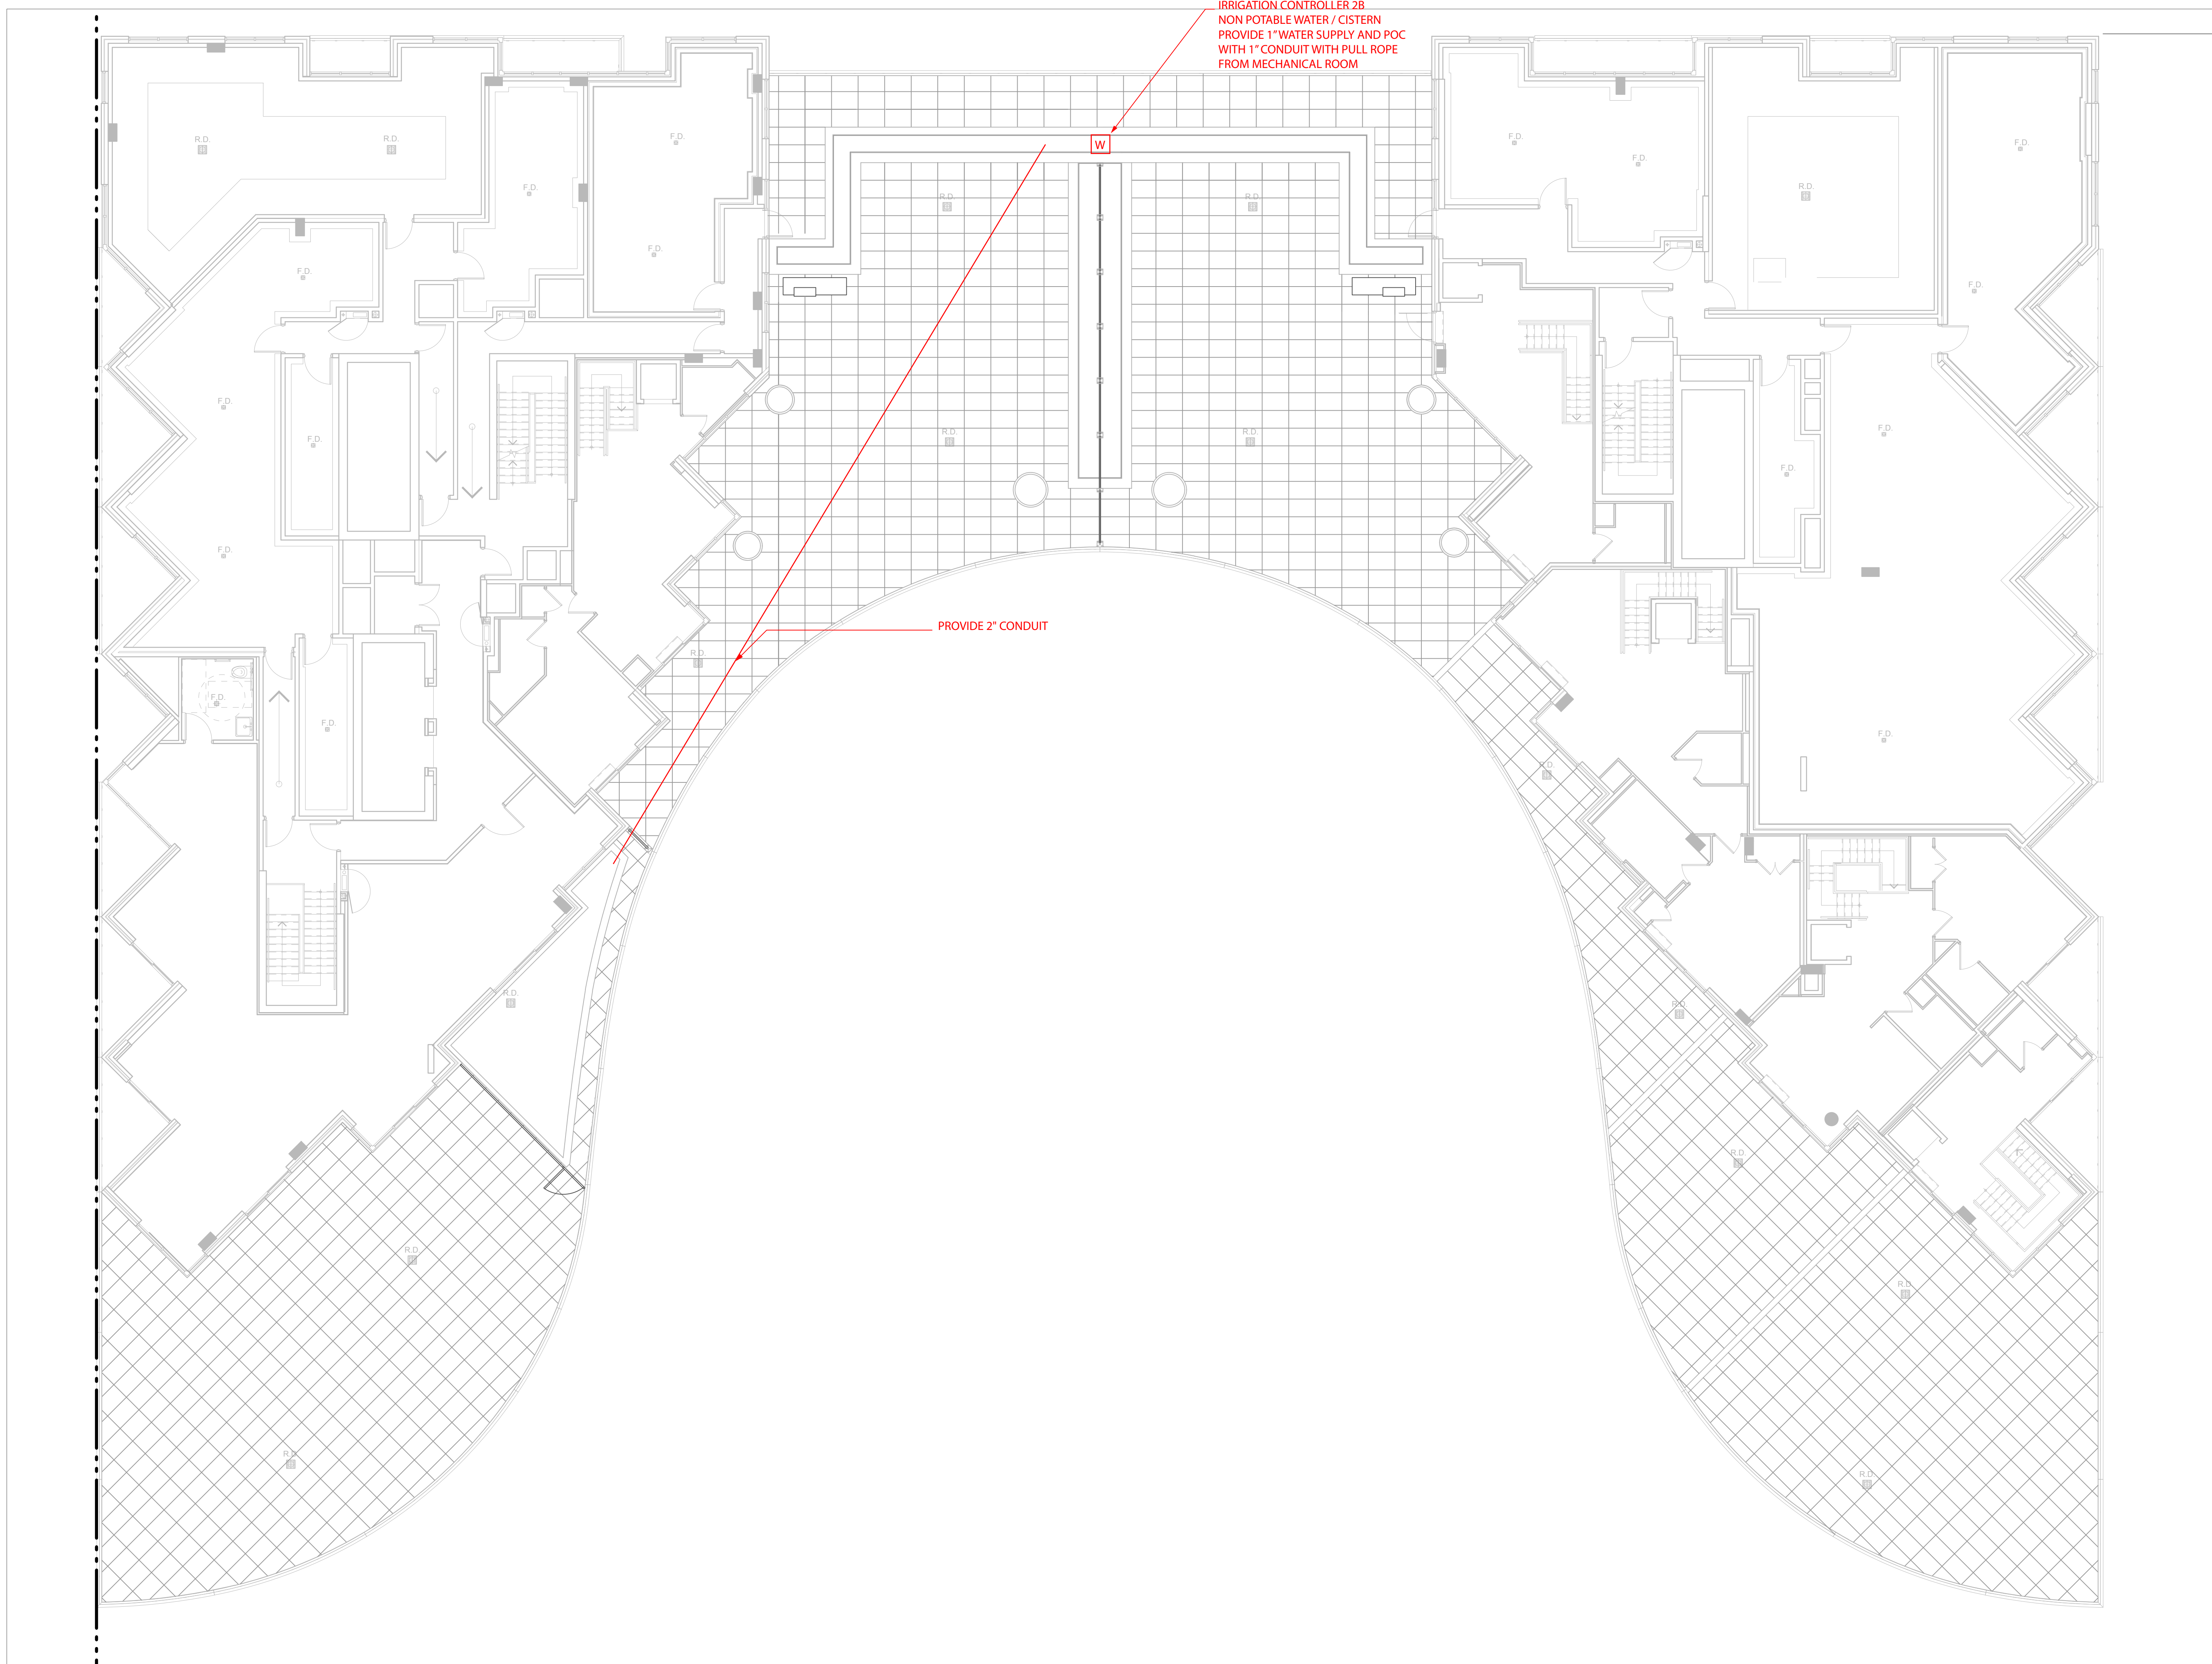

IRRIGATION CONTROLLER 2B
 NON POTABLE WATER / CISTERN
 PROVIDE 1" WATER SUPPLY AND POC
 WITH 1" CONDUIT WITH PULL ROPE
 FROM MECHANICAL ROOM

PROVIDE 2" CONDUIT

Contractor Must Check And Verify All Dimensions On The Job.
 Do Not Scale The Drawings.
 All Drawings, Specifications And Related Documents Are The
 Copyright Of
 The Architect And Must Be Returned Upon Request.
 Reproduction Of Drawings, Specifications And Related Documents
 In Part Or Whole Is Forbidden Without The Architects Written
 Permission.
 This Drawing Is Not To Be Used For Construction Until Signed
 By The Architect.
 Date:

**Janet
 Rosenberg
 & Studio**
 Landscape Architecture and Urban Design
 t 416 656 6665 f 416 656 5756 www.jrstudio.ca
 148 Kenwood Avenue, Toronto Ontario M6C 2S3 Canada

PROGRESS
 APRIL 24, 2015

No.:	Revision	Date
1.	Issued for Site Plan Approval to WT	15.01.30
2.	Issued for Site Plan Approval	15.03.04



Drawing
 Title
**Landscape Layout
 Penthouse 2 Level
 (13th Floor)**

Project

Hines TRIDEL

Aquavista

BAYSIDE, TORONTO

Scale

1 : 100


Drawn
 by
 CP


Checked
 by
 RB

Project
 No.
 14-117


Date
 09/02/14

Drawing
 No.
L-213

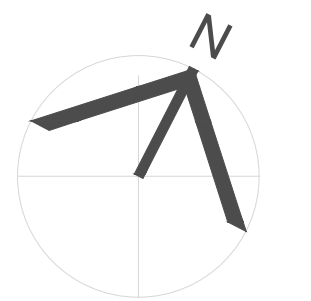

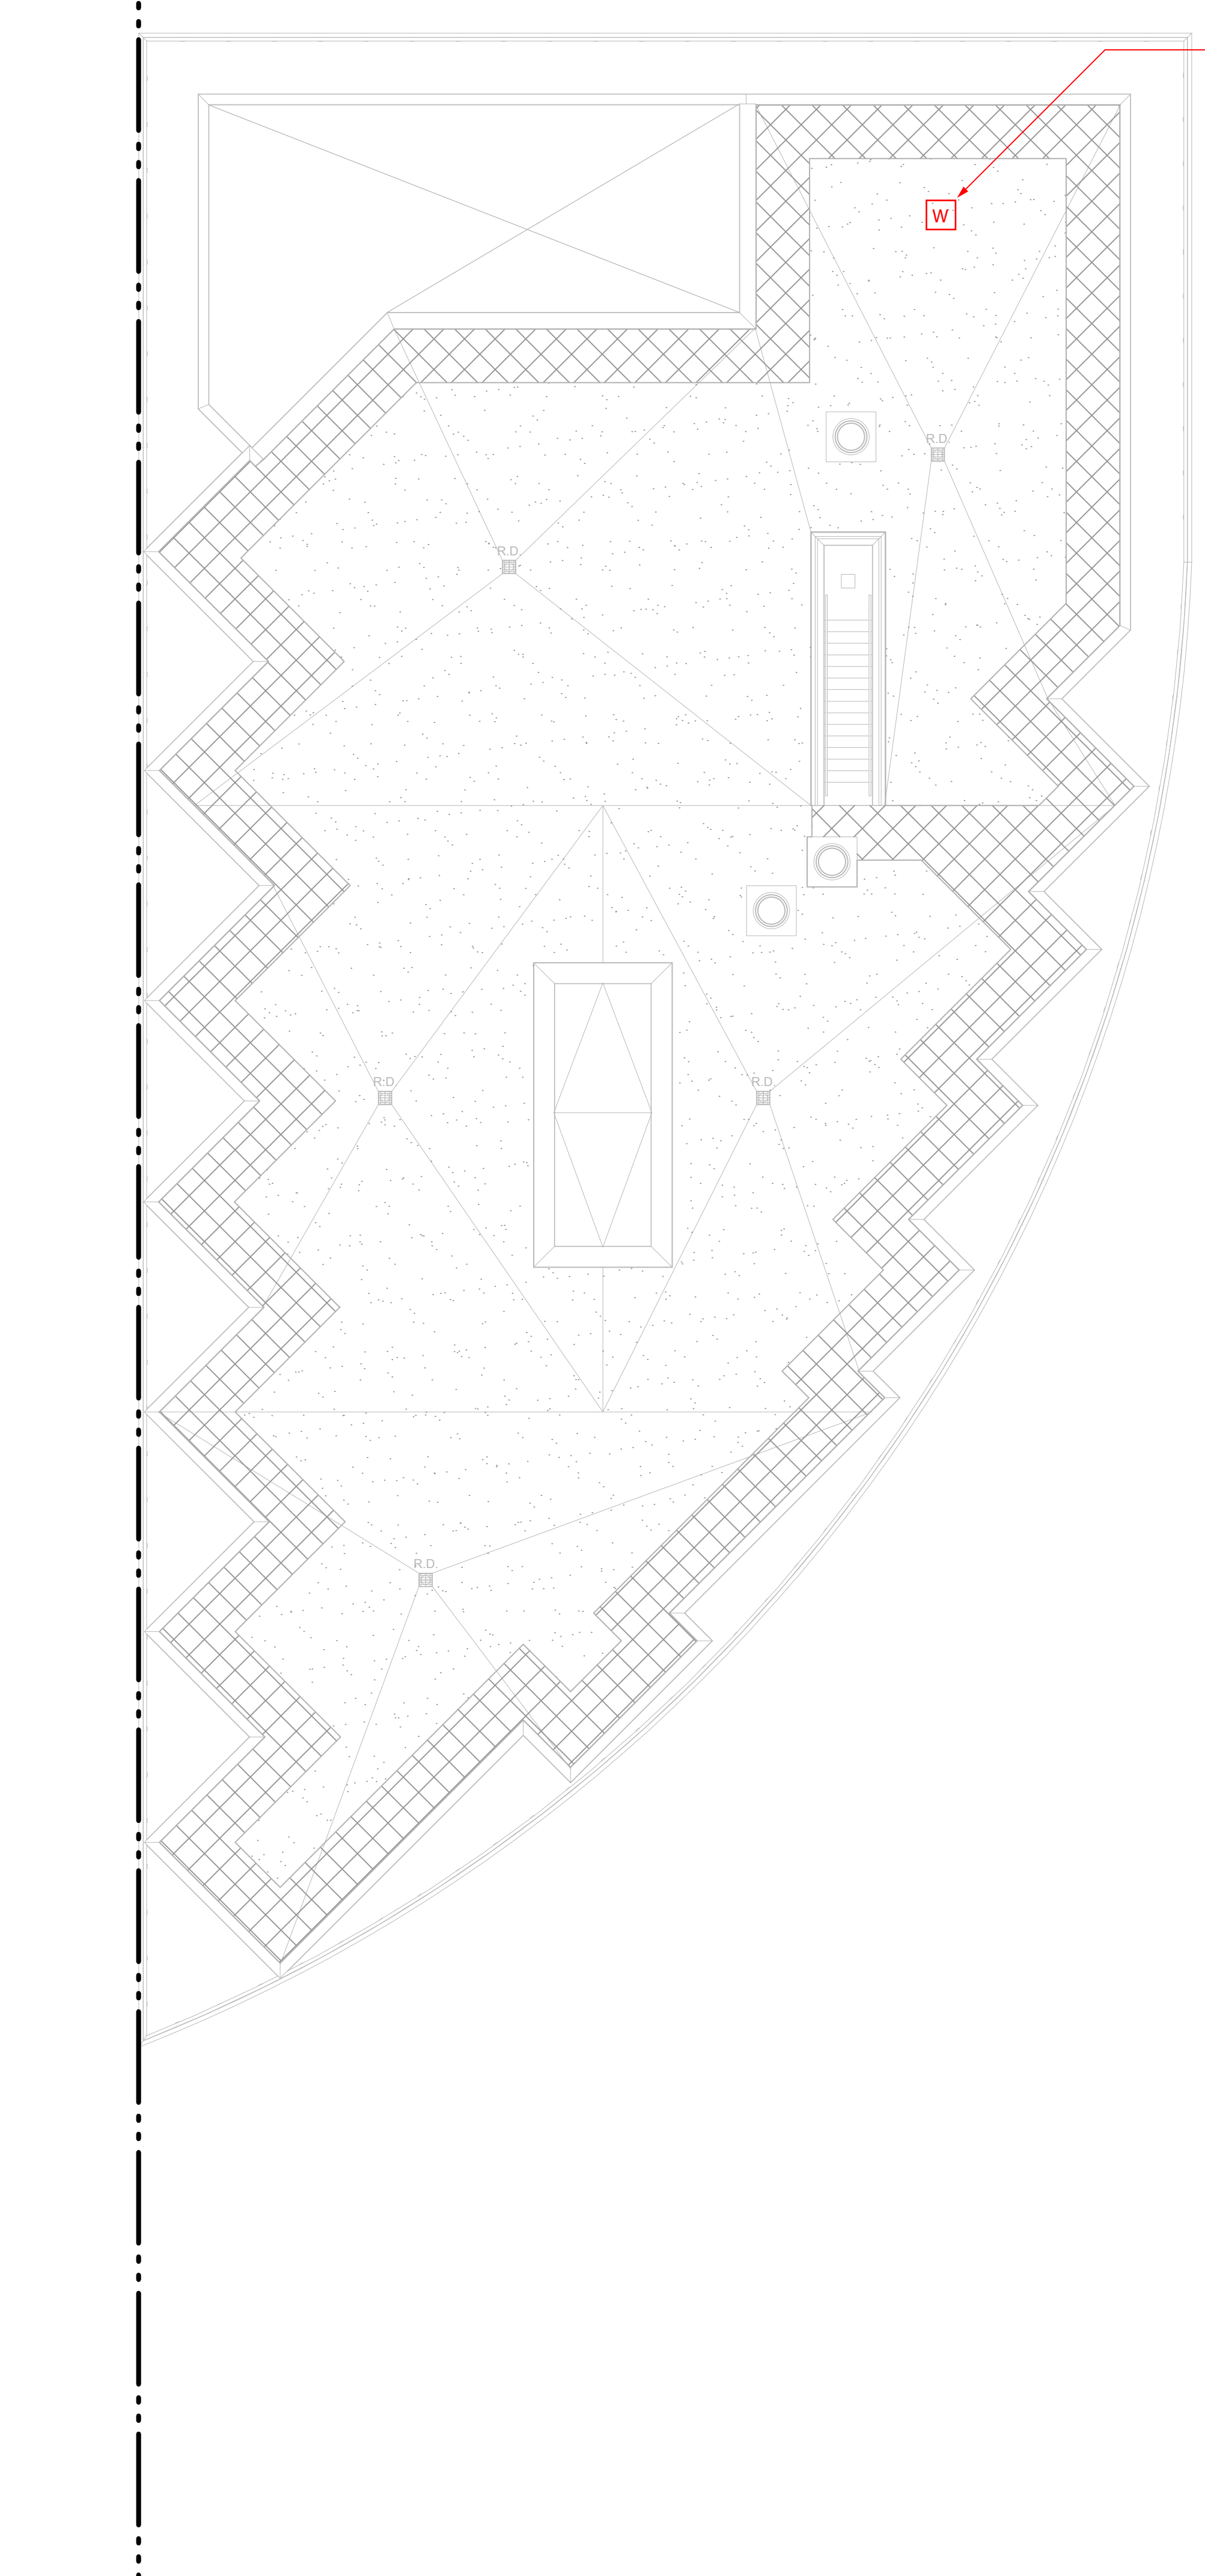

IRRIGATION CONTROLLER 2B
 NON POTABLE WATER / CISTERN
 PROVIDE 1" WATER SUPPLY AND POC
 WITH 1" CONDUIT WITH PULL ROPE
 FROM MECHANICAL ROOM

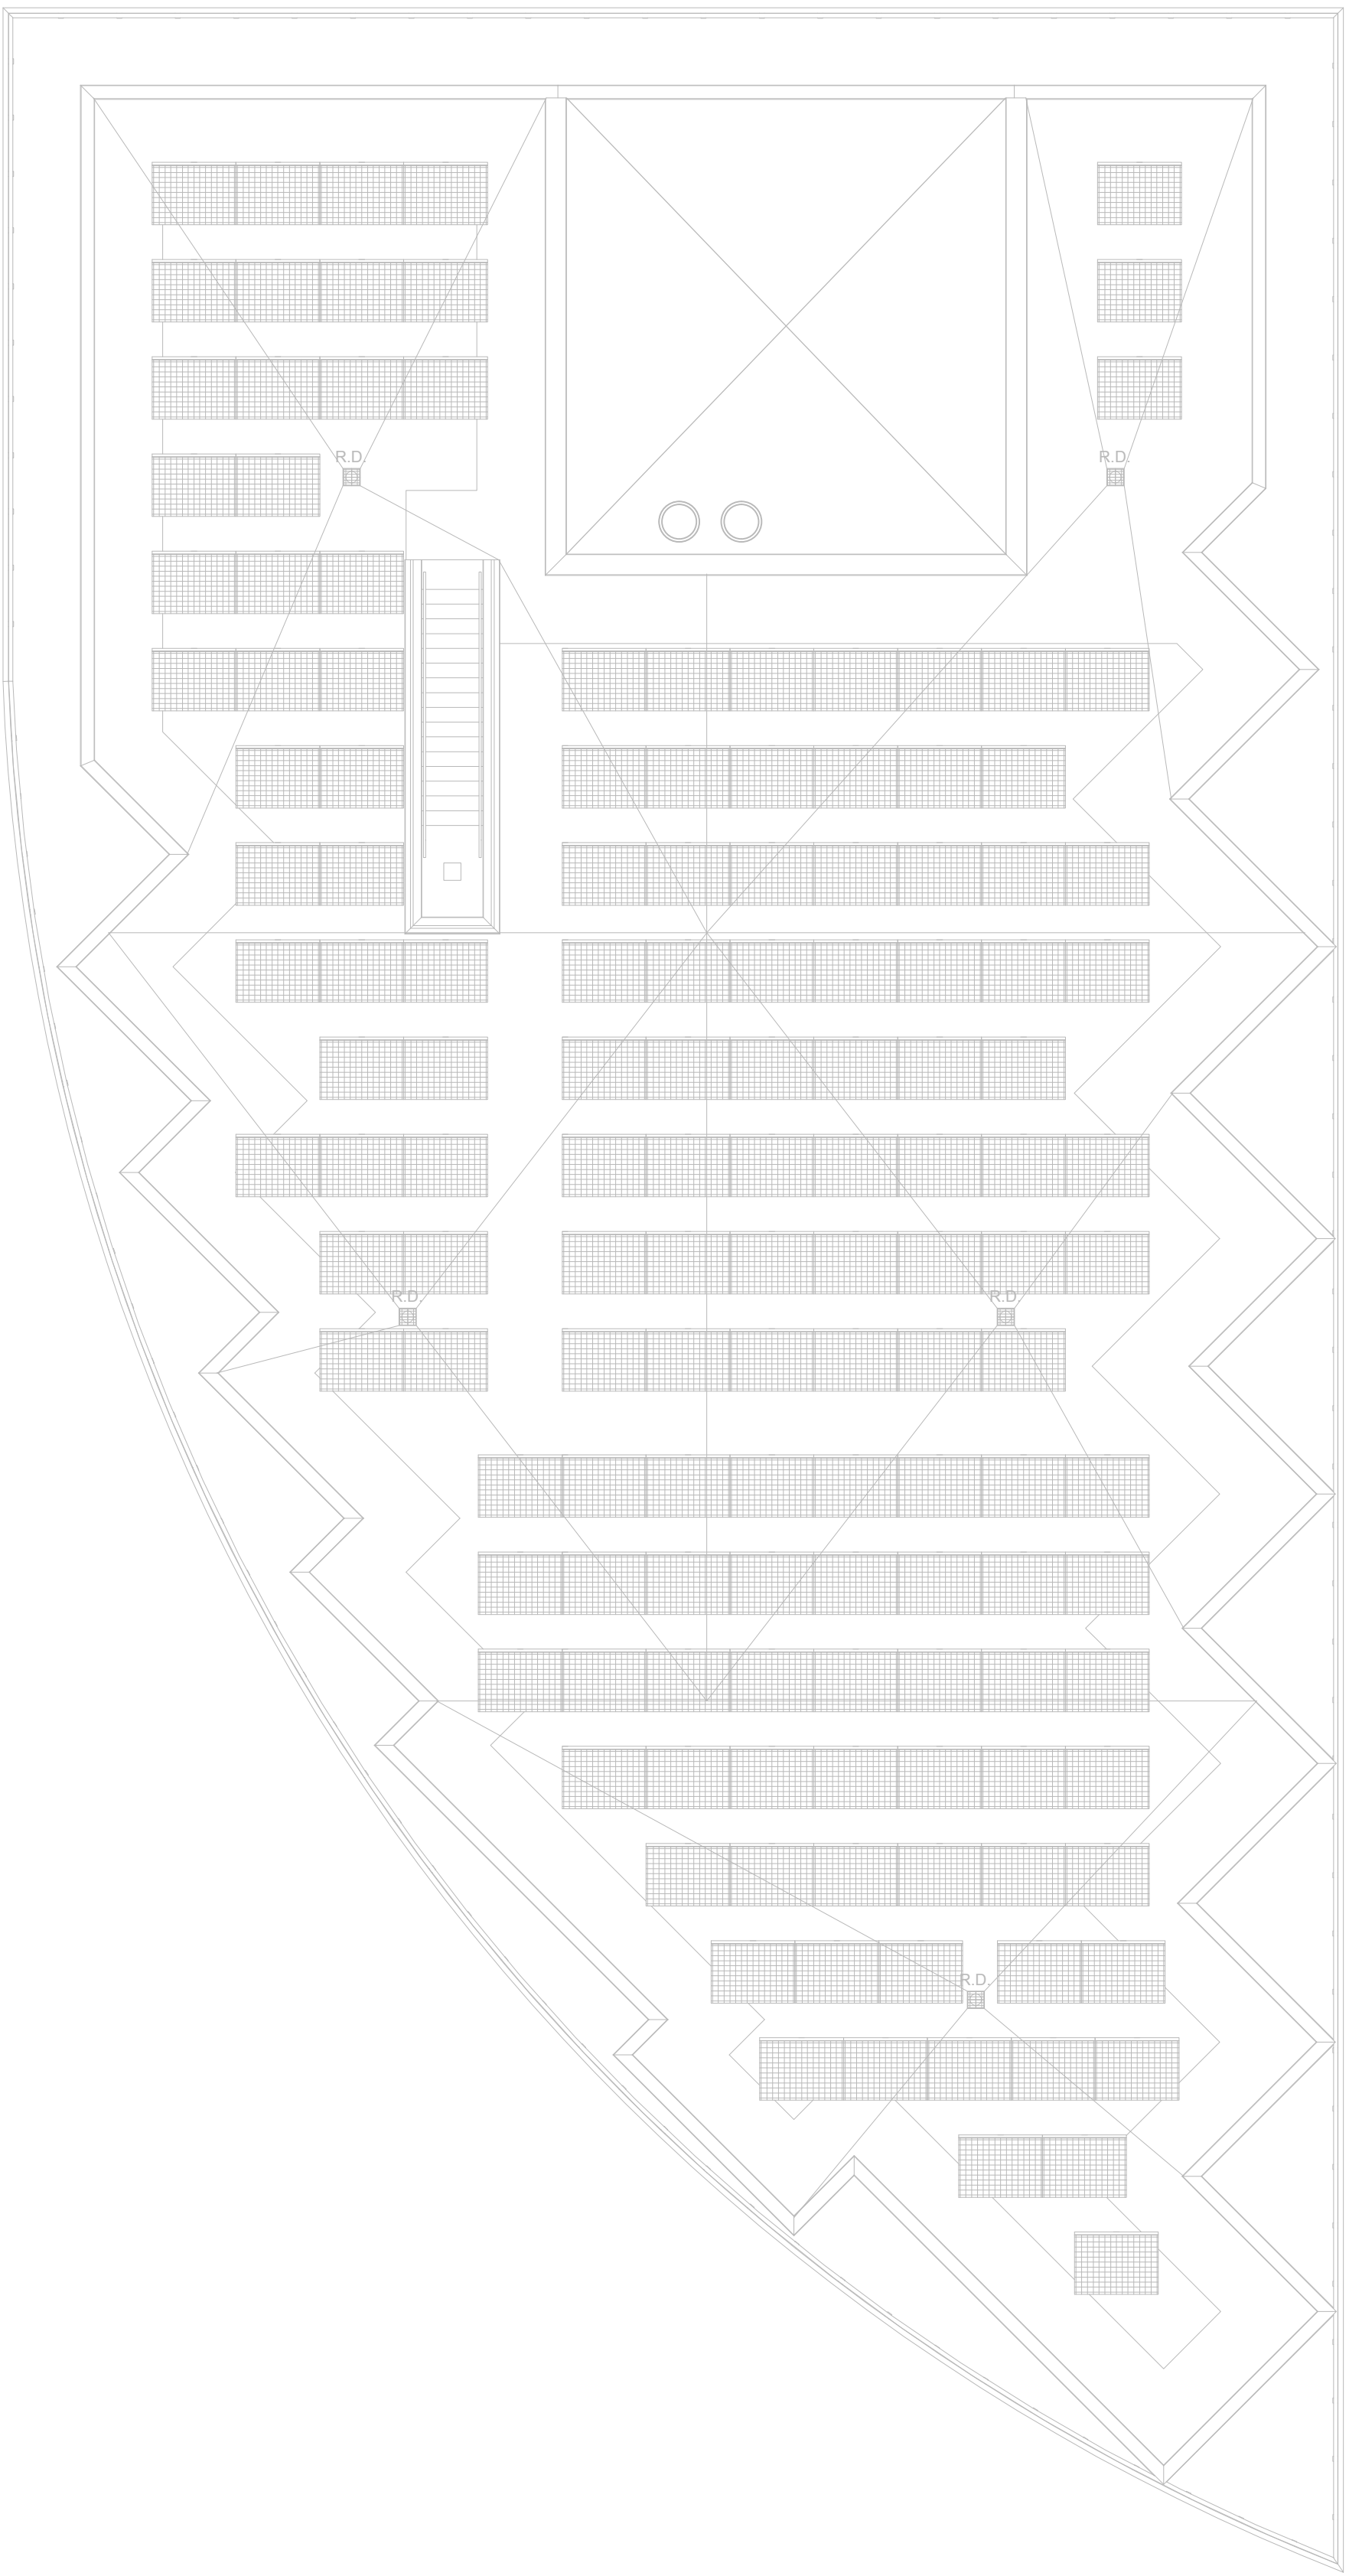

Contractor Must Check And Verify All Dimensions On The Job.
 Do Not Scale The Drawings.
 All Drawings, Specifications And Related Documents Are The
 Copyright Of
 The Architect And Must Be Returned Upon Request.
 Reproduction Of Drawings, Specifications And Related Documents
 In Part Or Whole Is Forbidden Without The Architects Written
 Permission.
 This Drawing Is Not To Be Used For Construction Until Signed
 By The Architect.
 Date:

**Janet
 Rosenberg
 & Studio**
 Landscape Architecture and Urban Design
 t 416 656 6665 f 416 656 5756 www.jrstudio.ca
 148 Kenwood Avenue, Toronto Ontario M6C 2S3 Canada


No.:	Revision	Date
1.	Issued for Site Plan Approval to WT	15.01.30
2.	Issued for Site Plan Approval	15.03.04



Drawing
 Title
**Landscape Layout
 Level 14 Greenroof**
 Project

Hines TRIDEL®

Aquavista
 BAYSIDE, TORONTO
 Scale
 1 : 100
 Drawn by
 CP
 Checked by
 RB
 Project No.
 14-117
 Date
 09/02/14

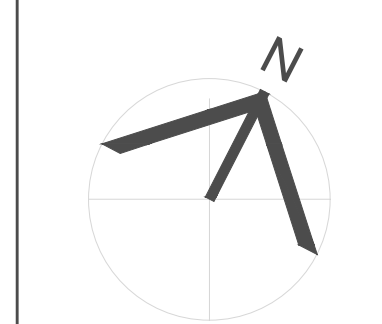

Drawing
 No.
L-214